


ITEM	115-C-101
SERVICE	C4 EXTRACTOR
IDxTL-TL (mm x mm)	1700X18700
DESIGN PRESS	24.0/FV barg
DESIGN TEMP	85°C
INSULATION	YES

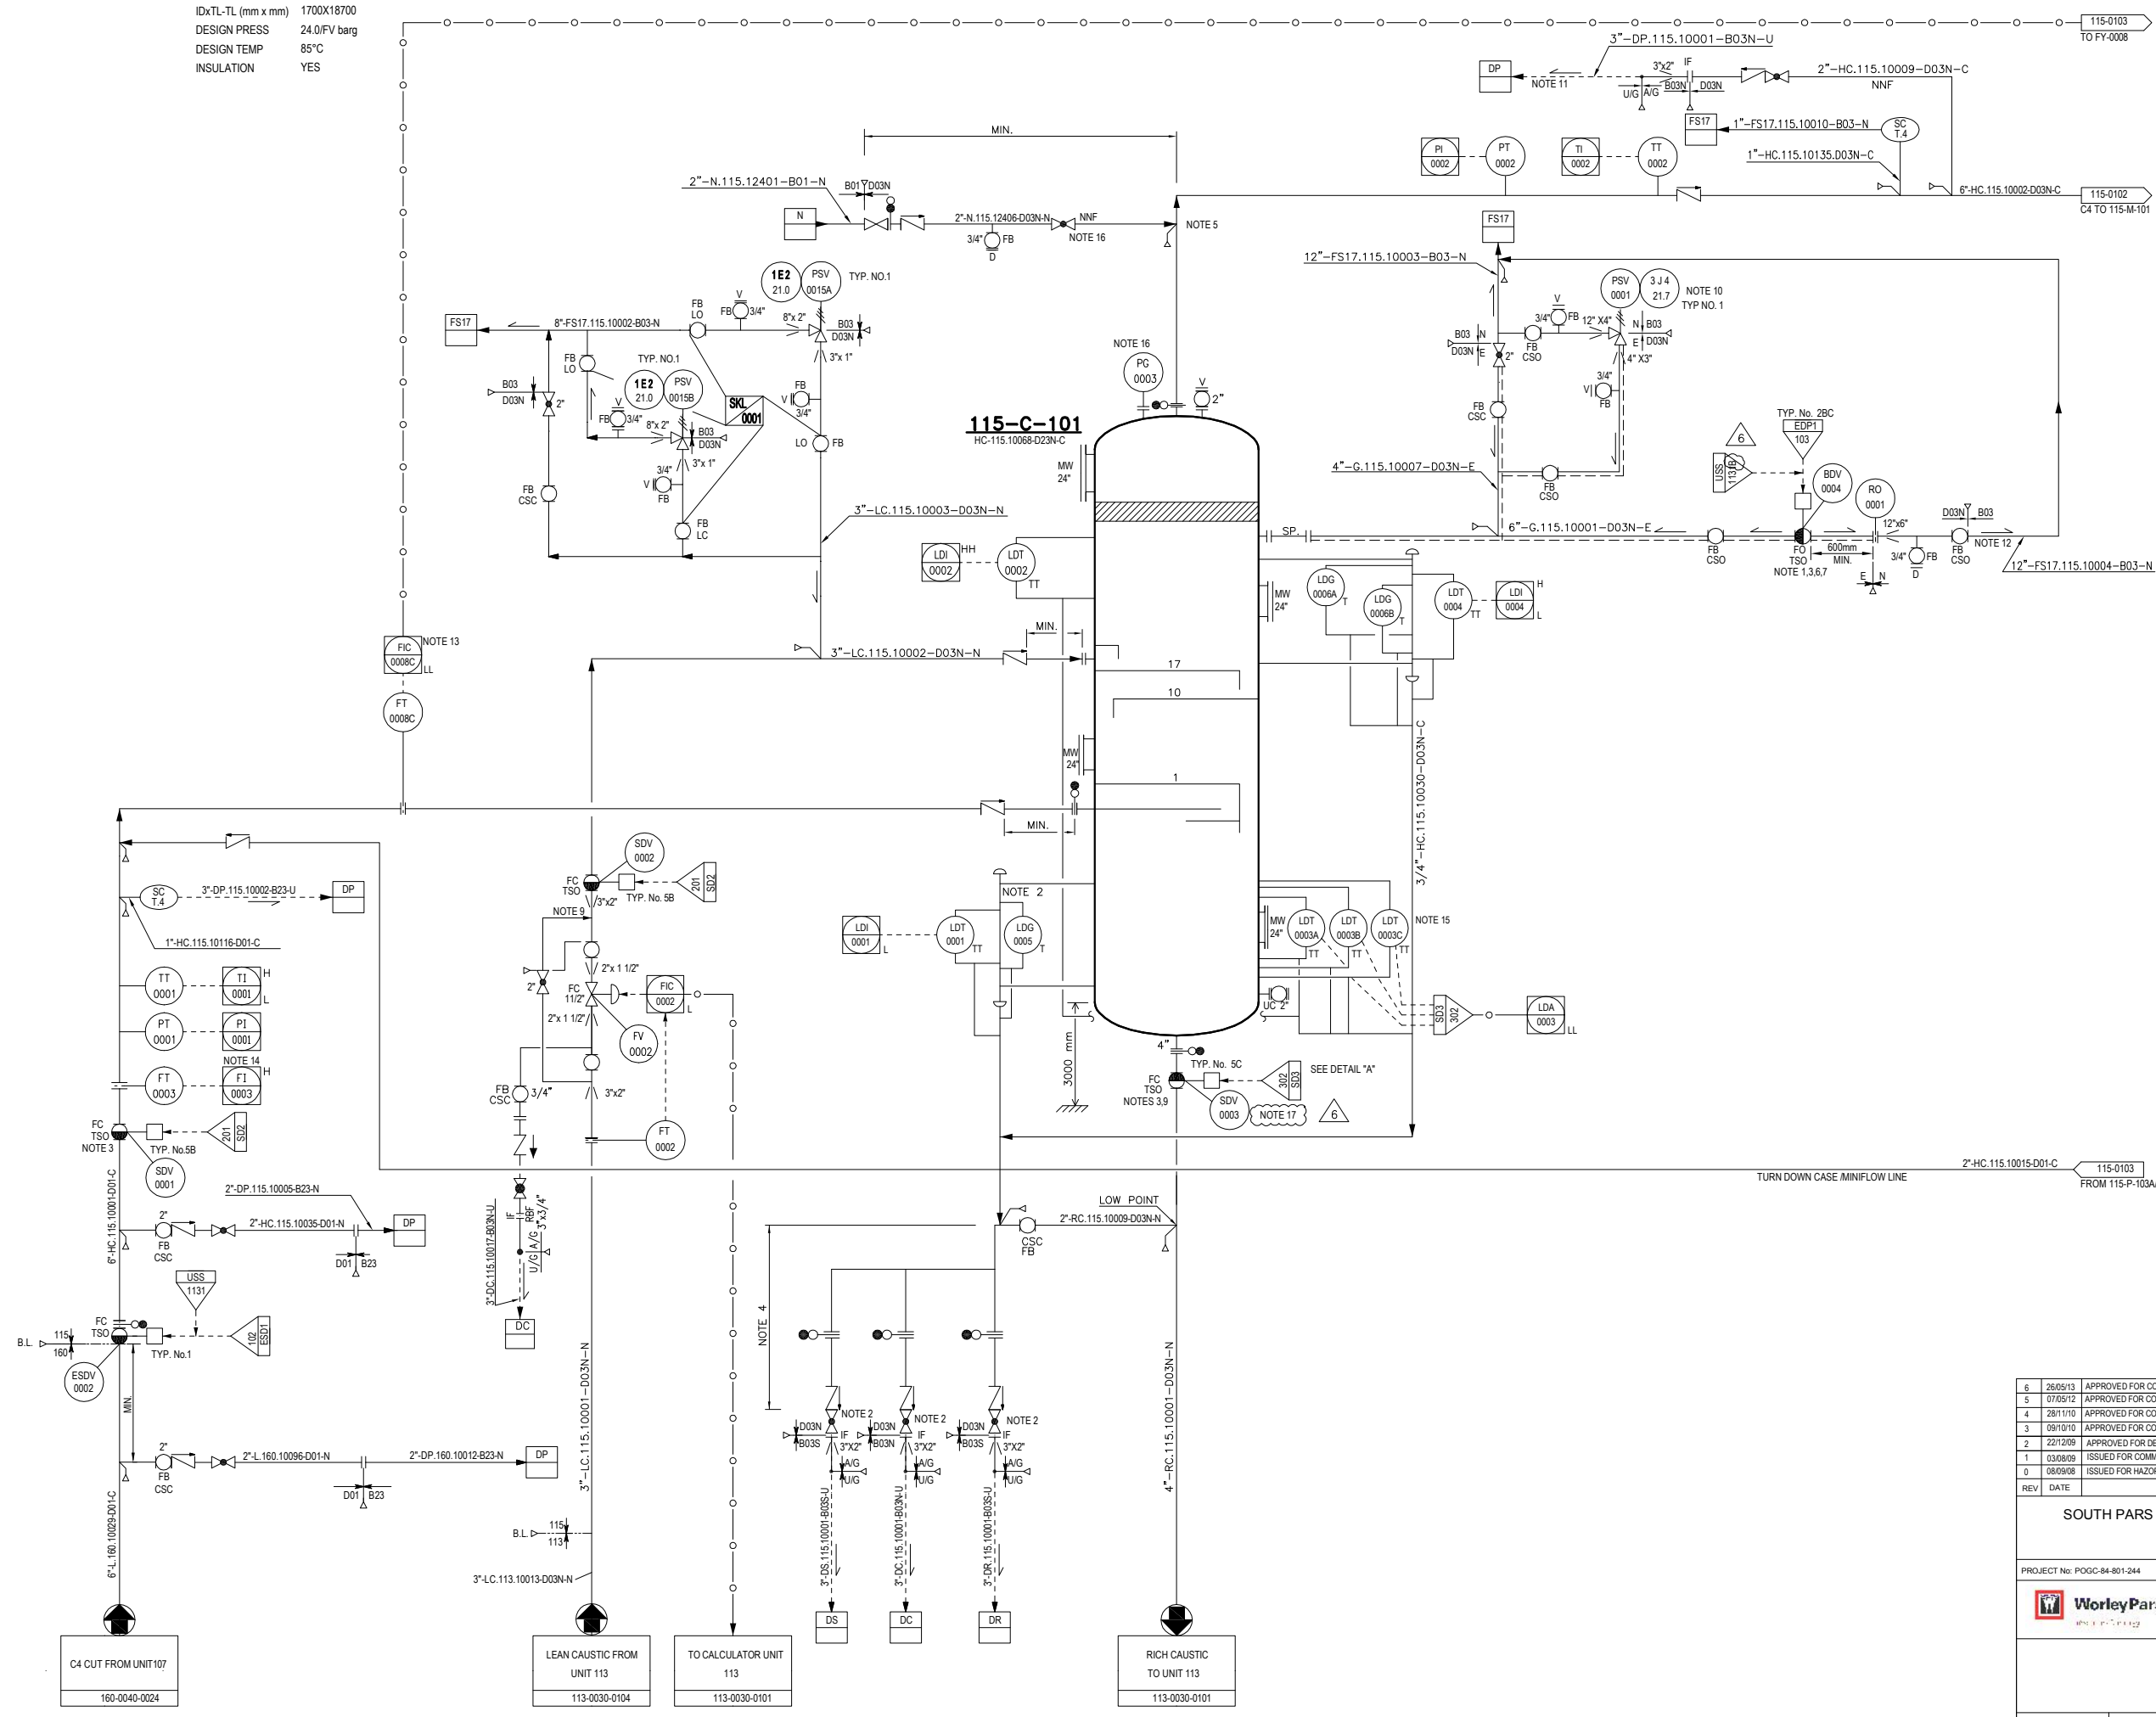


- NOTES**
- 1 - VALVE EQUIPPED WITH AIR RESERVE.
 - 2 - LDG ON 115-C-101 READABLE FROM SPENT CAUSTIC DRAINAGE VALVE FACILITIES.
 - 3 - FIRE RESISTANT VALVE (ALL INSTRUMENTS, BOX PROTECTION, TUBING, CABLES, ETC., WILL BE SELECTED AND CLASSIFIED ACCORDING TO THIS PROTECTION).
 - 4 - PRESENCE OF LPG. POSSIBILITY OF FREEZING VALVES IN CASE OF MISOPERATION. MINIMUM DISTANCE BETWEEN 2 VALVES SHALL BE 600 mm.
 - 5 - CONNECTION ON TOP OF THE LINE.
 - 6 - VALVE LOCATED AT HIGH POINT.
 - 7 - AIR RESERVE TO BE SIZED TO BE ABLE TO COMMAND FOR 3 STROKES VALVE OPERATING DURING AIR INSTRUMENT FAILURE.
 - 8 - DELETED.
 - 9 - ISOLATION VALVE TO BE LOCATED AT MINIMUM DISTANCE FROM 115-C-101.
 - 10 - SPARE RELIEF VALVE STORED IN WAREHOUSE.
 - 11 - LINE USED FOR DRAINING NON CONDENSABLE GASES.
 - 12 - TWO PHASES FLOW LINE NEED FOR REINFORCED ANCHORING.
 - 13 - IN CASE OF LOW FLOW ALARM, OPERATOR TO START 115-P-103.
 - 14 - IN CASE OF HIGH FLOW ALARM, OPERATOR TO STOP 115-P-103.
 - 15 - PROVIDE 2 OUT OF 3 VOTING SYSTEM.
 - 16 - PG 0003 TO BE READABLE FROM GLOBE VALVE.
 - 17 - LAHH-0004 AB/C IN UNIT 113 INITIATE CLOSURE OF SDV-0003.

GENERAL NOTES

ALL INSTRUMENT TAGS TO READ:
LETTERS NUMBER
1151 FFFF NNNN

- HOLDS**
- 1 - DELETED.
 - 2 - DELETED.

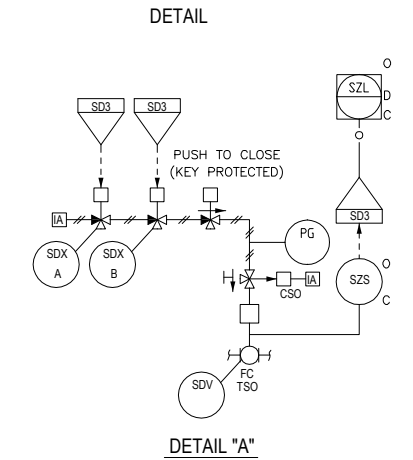

THIS P&ID IS BASED ON DRAWING NO. 115-SPD-1/6 SUPPLIED BY AXENS.

EQUIPMENT LIST			
COLUMN			
115-C-101			

UTILITY PID NUMBER			
FS17	PID-1718-186-0040-0004	DR	PID-1718-186-0040-0005
DC	PID-1718-186-0040-0005	DP	PID-1718-186-0040-0005
DS	PID-1718-186-0040-0005		
N	PID-1718-186-0040-0002		

6	26/05/13	APPROVED FOR CONSTRUCTION	OIEC	SD	SM	SM	RM
5	07/05/12	APPROVED FOR CONSTRUCTION	OIEC	SM	MMH	SM	RM
4	28/11/10	APPROVED FOR CONSTRUCTION	OIEC	SM	MA	MMF	AAP
3	09/10/10	APPROVED FOR CONSTRUCTION	OIEC	SM	MA	MMF	AAP
2	22/12/09	APPROVED FOR DESIGN	OIEC	SM	MA	MMF	AAP
1	03/08/09	ISSUED FOR COMMENT	OIEC	SM	MA	MMF	AAP
0	08/09/08	ISSUED FOR HAZOP	WP	SH	AI	RPW	RC
REV	DATE	DESCRIPTION	ORIGI	PRPD	CHD	APPD	AUTHD

SOUTH PARS GAS FIELD DEVELOPMENT PHASES 17&18
ASSALUYEH-IRAN
ONSHORE FACILITIES

PROJECT No: POGC-84-801-244

DOC. CLASS 1 SCALE: N/A

WorleyParsons **IDRO** **OIEC** **IOEC**

UNIT 115: BUTANE TREATMENT AND DRYING
C4 EXTRACTOR
PIPING AND INSTRUMENT DIAGRAM

DRAWING No. PID-1718-115-0030-0101 REVISION 6

POGC

IOEC

ITEM 115-D-101
SERVICE C4 WATER WASH DRUM
IDXTL.TL 2300 mm X 9200 mm
DESIGN PRESSURE 24.0 /FV barg
DESIGN TEMPERATURE 85°C
INSULATION YES

ITEM 115-P-101 A/B (2x100%)
SERVICE C4 WATER CIRCULATION PUMPS
TYPE CENTRIFUGAL
CAPACITY 10.0 m3/h
DIFFERENTIAL PRESSURE 3.8 bar
ABSORBED POWER 3.3 kW

ITEM 115-M-101
SERVICE C4 EXTRACTOR STATIC MIXER
DESIGN PRESSURE 24.0 bar g
DESIGN TEMPERATURE 85°C

ITEM 115-P-104 A/B (2x100%)
SERVICE C4 WATER MAKE-UP PUMPS
TYPE RECIPROCATING
CAPACITY 0.2 m3/h
DIFFERENTIAL PRESSURE 3.5 bar
ABSORBED POWER 3 kW

NOTES

- LDG ON 115-D-105 TO BE READABLE FROM GLOBE VALVES, ON VESSEL DRAINS.
- BY-PASS FOR 101 C4 WATER WASH DRUM FILLING DURING START-UP.
- LINE TO BE DRAINABLE TO 115-D-101 OR TO 115-F-101 TO AVOID WATER ACCUMULATION IN LOW POINTS.
- VALVE EQUIPPED WITH AIR RESERVE.
- FIRE RESISTANT VALVE (ALL INSTRUMENTS, BOX PROTECTION, TUBING, CABLES, ETC. WILL BE SELECTED AND CLASSIFIED ACCORDING TO THIS PROTECTION).
- DELETED.
- CONNECTION ON TOP OF THE LINE.
- PRESERVE OF LPG, POSSIBILITY OF FREEZING VALVES IN CASE OF MISOPERATION. MINIMUM DISTANCE BETWEEN 2 VALVES SHALL BE 600 mm.
- SPARE RELIEF VALVES STORED IN WAREHOUSE.
- VALVE LOCATED AT HIGH POINT.
- AIR RESERVE TO BE SIZED TO BE ABLE TO COMMAND FOR 3 STROKES VALVE OPERATING DURING AIR INSTRUMENT FAILURE.
- DELETED.
- TO BE LOCATED FAR FROM PUMPS. FLOWRATE IS ADJUSTED MANUALLY
- ISOLATION VALVE TO BE LOCATED AT MINIMUM DISTANCE FROM 115-D-101.
- TWO PHASES FLOW LINES, NEED FOR REINFORCED ANCHORING.
- FOR FILTER ARRANGEMENT REFER TO TABLE "A" ON PID-1718-999-0030-0006
- ON LOW FLOW DUTY PUMP IS STOPPED AND STANDBY PUMP STARTED. IF AFTER 30 SECONDS FLOW REMAINS LOW LOW, BOTH PUMPS ARE TRIPPED.
- LAHH-0008 IS ALARM ONLY.
- SDV-0005 CLOSED INDICATION TRIPS AMINE SOLUTION CIRCULATION PUMPS 115-P-101A/B WHEN RUNNING.
- PSV, PULSATION DAMPENER AND ALL OTHER REQUIRED ACCESSORIES (AS PER PROJECT SPECIFICATION) SHALL BE SUPPLIED BY PUMP VENDOR.

GENERAL NOTES

ALL INSTRUMENT TAGS TO READ:
LETTERS NUMBER
1131 FFFF NNNN

HOLDS

- DELETED.
- DELETED.
- DELETED.

THIS P&ID IS BASED ON DRAWING NO. 115-SPD-26 SUPPLIED BY AXENS.

EQUIPMENT LIST

DRUM	MIXER	PUMPS	
115-D-101	115-M-101	115-P-101A/B	
		115-P-104A/B	

UTILITY PID NUMBER

DC	PID-1718-186-0040-0005
FS17	PID-1718-186-0040-0004
DR	PID-1718-186-0040-0005
SC	PID-1718-186-0040-0005

7	26/09/13	APPROVED FOR CONSTRUCTION	OIEC	SD	SM	SM	RM
6	07/05/12	APPROVED FOR CONSTRUCTION	OIEC	SM	MM	MM	RM
5	28/11/10	APPROVED FOR CONSTRUCTION	OIEC	SM	MA	MMF	AAP
4	09/10/10	APPROVED FOR CONSTRUCTION	OIEC	SM	MA	MMF	AAP
3	22/12/09	APPROVED FOR DESIGN	OIEC	SM	MA	MMF	AAP
2	03/08/09	ISSUED FOR COMMENT	OIEC	SM	MA	MMF	AAP
1	28/11/08	APPROVED FOR DESIGN	WP	SH	AI	RPW	RC
0	03/09/08	ISSUED FOR HAZOP	WP	SH	AI	RPW	RC
REV	DATE	DESCRIPTION	ORIG	PRPD	CHD	APPD	AUTHD

SOUTH PARS GAS FIELD DEVELOPMENT PHASES 17&18
ASSALUYEH-IRAN
ONSHORE FACILITIES



PROJECT No: POGC-84-801-244

DOC. CLASS

1

SCALE:

N/A



UNIT 115: BUTANE TREATMENT AND DRYING
WATER WASH DRUM
PIPING AND INSTRUMENT DIA/GRAM

DRAWING No. PID-1718-115-0030-0102 REVISION 7

115-M-101


115-D-101
HC-115.10037-D23N-C

115-P-101A

115-P-101B

115-P-104A

115-P-104B

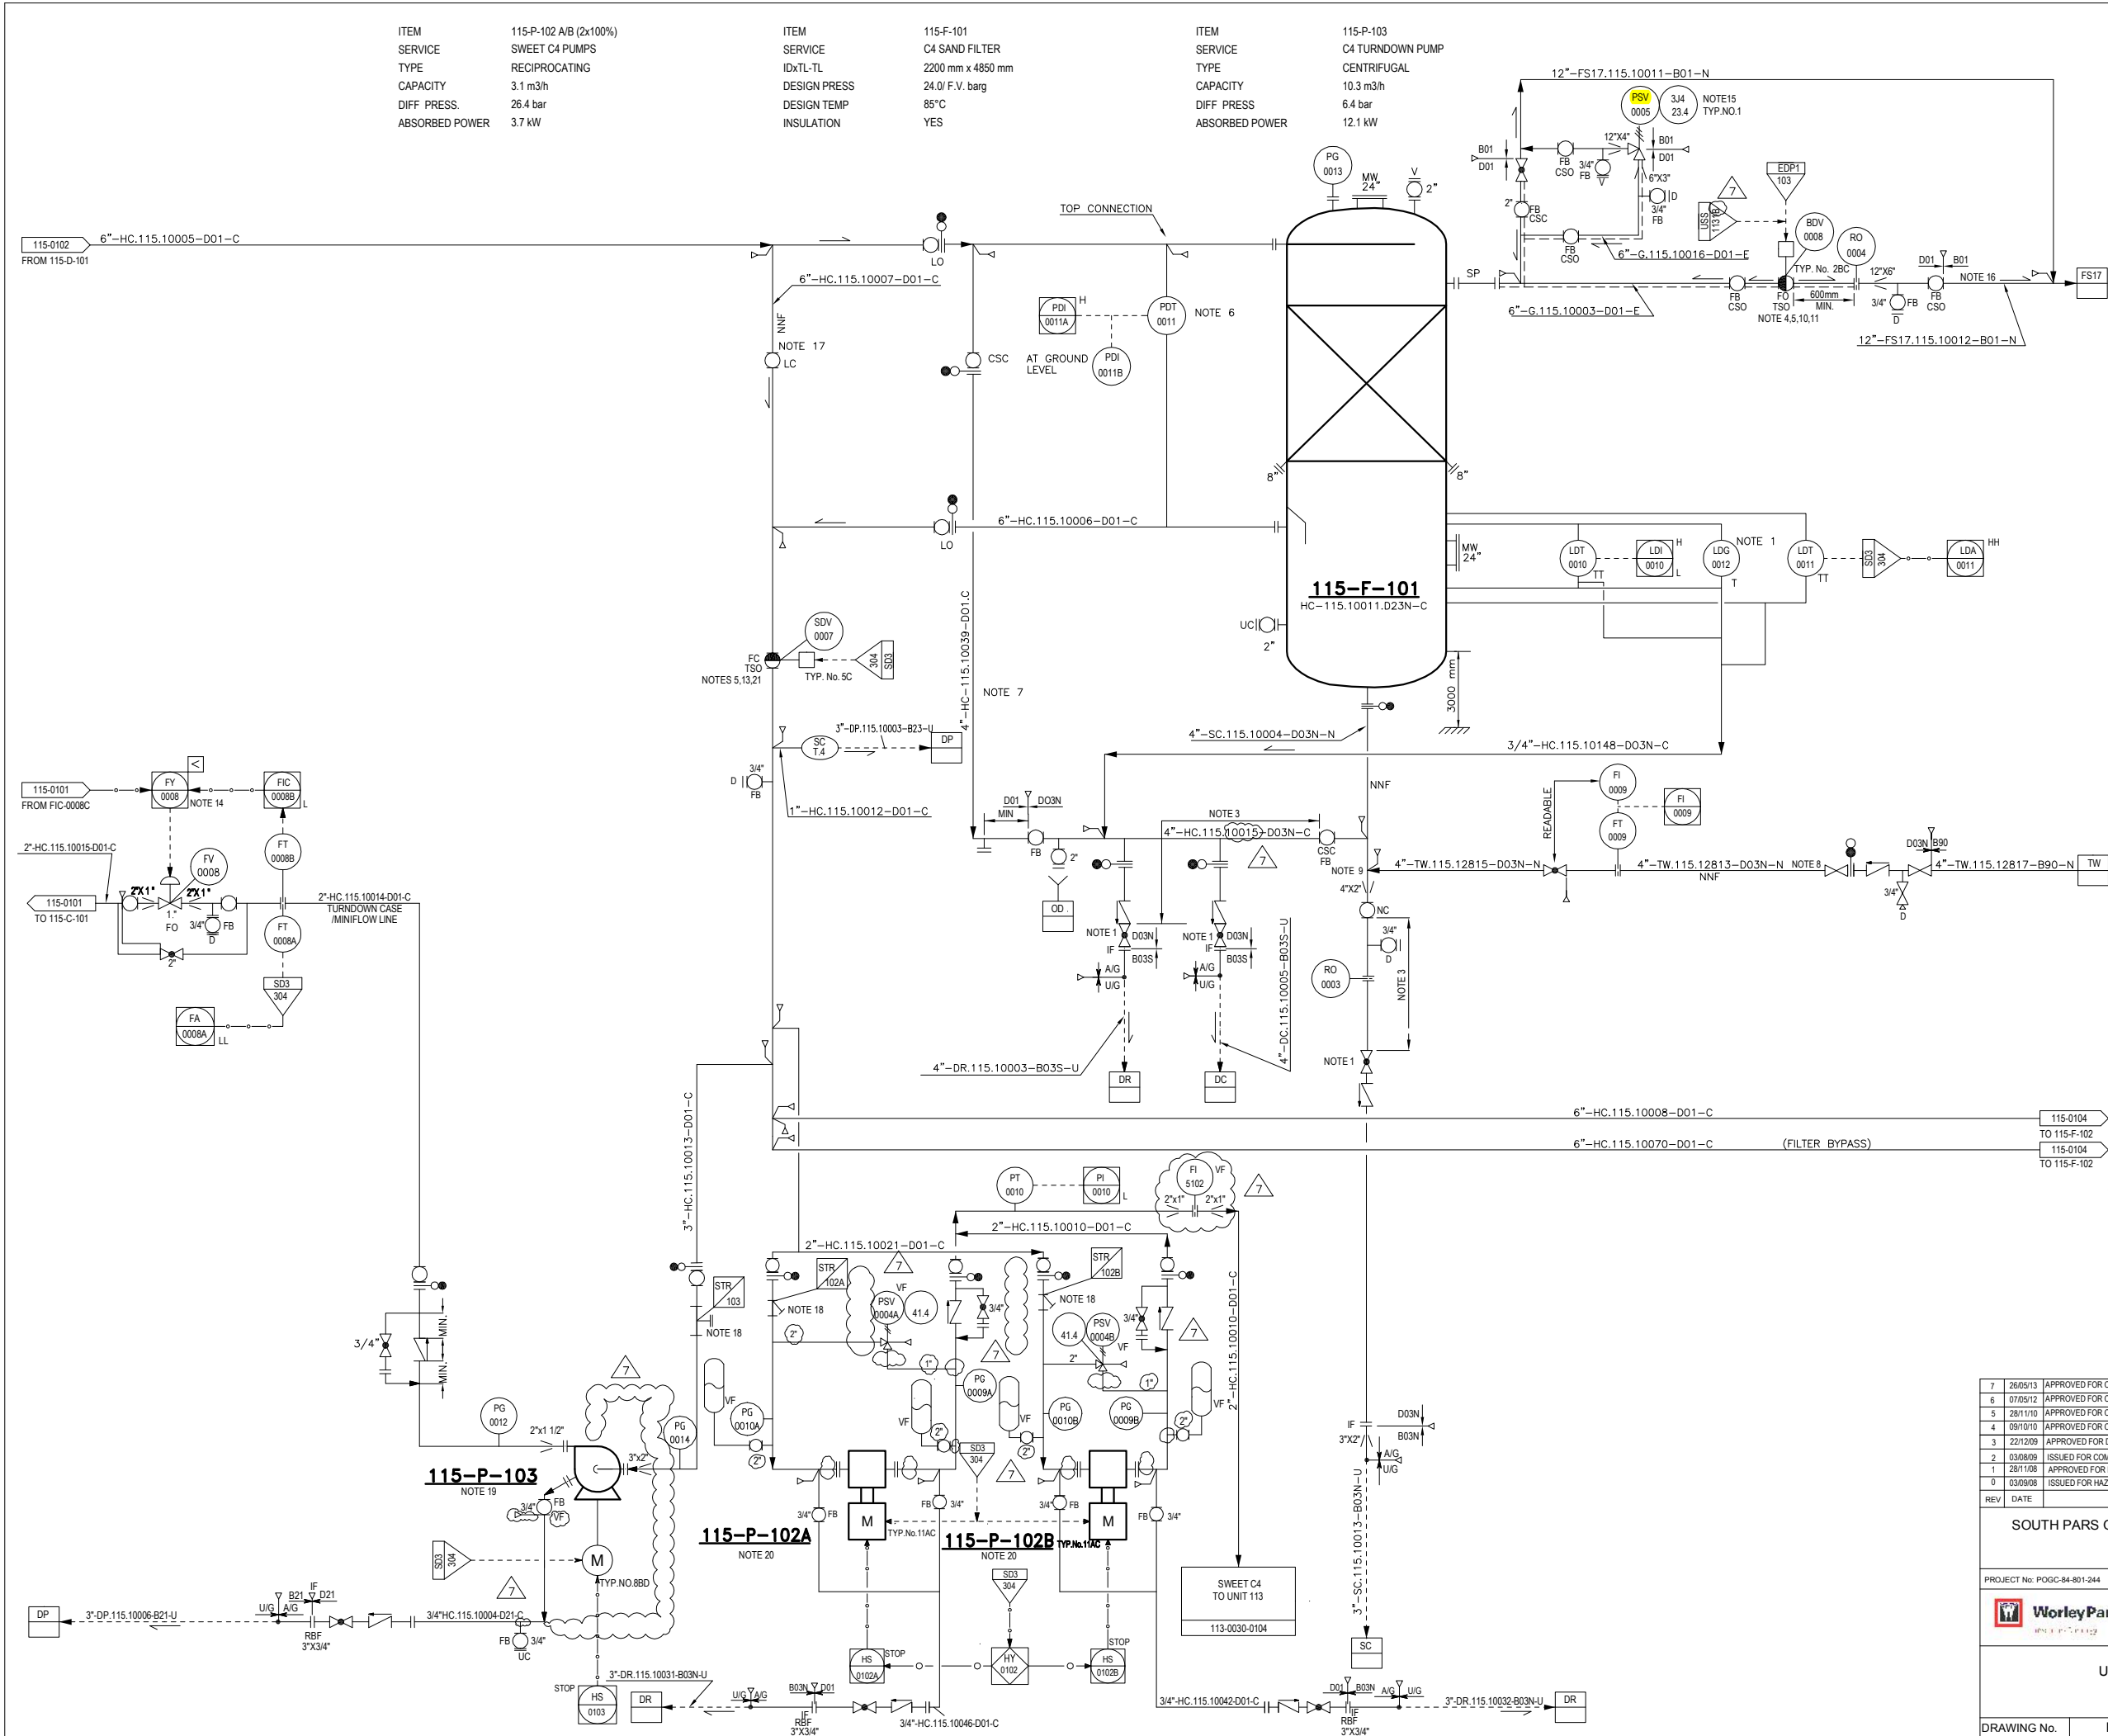

- NOTES**
- LDG ON 115-F-101 TO BE READABLE FROM GLOBE VALVES ON DRAIN LINES.
 - SAND BED.
 - PRESENCE OF C4, POSSIBILITY OF FREEZING VALVES IN CASE OF MISOPERATION. MINIMUM DISTANCE BETWEEN 2 VALVES SHALL BE 600 mm.
 - VALVE EQUIPPED WITH AIR RESERVE.
 - FIRE RESISTANT VALVE (ALL INSTRUMENTS, BOX PROTECTION, TUBING, CABLES, ETC., WILL BE SELECTED AND CLASSIFIED ACCORDING TO THIS PROTECTION).
 - LOCATE DELTA P CELL AT LOW POINT. SELF DRAINING LEGS.
 - FILTER BACK-WASH DRAIN PIPING.
 - FOR SAND FILTER BACK-WASHING.
 - CONNECTION ON TOP OF THE LINE.
 - AIR RESERVE TO BE SIZED TO BE ABLE TO COMMAND FOR 3 STROKES VALVE OPERATING DURING AIR INSTRUMENT FAILURE.
 - VALVE LOCATED AT HIGH POINT
 - DELETED.
 - ISOLATION VALVE TO BE LOCATED AT MINIMUM DISTANCE FROM 115-F-101.
 - SEE SPECIAL LOOP DESCRIPTION IN SECTION 4 OF PROCESS DATA BOOK.
 - SPARE RELIEF VALVE STORED IN WAREHOUSE.
 - TWO PHASES FLOW LINE NEED FOR REINFORCED ANCHORING.
 - SAND FILTER BY-PASS FOR MAINTENANCE.
 - FOR FILTER ARRANGMENT REFER TO TABLE "A" ON PID-1718-999-0030-0006.
 - OPERATOR TO START THE PUMP WHEN IT IS NECESSARY.
 - PSV, PULSTION DAMPENER AND ALL REQUIRED ACCESSORIES (AS PER PROJECT SPECIFICATION) SHALL BE SUPPLIED BY PUMP VENDOR.
 - SDV-0007 CLOSED INDICATION TRIPS SWEET C4 PUMP
 - 115-P-102A/B AND C4 TURN DOWN 115-P-103 WHEN RUNNING.

GENERAL NOTES

ALL INSTRUMENT TAGS TO READ:

LETTERS	NUMBER
1151	FFFF NNNN

HOLDS

1- DELETED.
2- DELETED.
3- DELETED.

THIS P&ID IS BASED ON DRAWING NO. 115-SPD-3/8 SUPPLIED BY AXENS.

EQUIPMENT LIST			
FILTER	PUMP		
115-F-101	115-P-102A/B		
	115-P-103		

UTILITY PID NUMBER			
FS17	PID-1718-186-0040-0004	DC	PID-1718-186-0040-0005
DP	PID-1718-186-0040-0005	DR	PID-1718-186-0040-0005
TW	PID-1718-186-0040-0003	SC	PID-1718-186-0040-0005

7	26/05/13	APPROVED FOR CONSTRUCTION	OIEC	SD	SM	SM	RM	
6	07/05/12	APPROVED FOR CONSTRUCTION	OIEC	SM	MHM	SM	RM	
5	28/11/10	APPROVED FOR CONSTRUCTION	OIEC	SM	MA	MMF	AP	
4	09/10/10	APPROVED FOR CONSTRUCTION	OIEC	SM	MA	MMF	AP	
3	22/12/09	APPROVED FOR DESIGN	OIEC	SM	MA	MMF	AP	
2	03/09/09	ISSUED FOR COMMENT	OIEC	SM	MA	MMF	AP	
1	28/11/08	APPROVED FOR DESIGN	WP	SH	AI	RPW	RC	
0	03/09/08	ISSUED FOR HAZOP	WP	SH	AI	RPW	RC	
REV	DATE	DESCRIPTION	ORIGI	PRPD	CHD	APPD	AUTH	
SOUTH PARS GAS FIELD DEVELOPMENT P HASES 17&18 ASSALUYEH-IRAN ONSHORE FACILITIES								
 POGC								
PROJECT No: POGC-84-801-244			DOC. CLASS		1	SCALE: N/A		
 WORLEYPARSONS			 IDRO		 OIEC		 I O B C	
UNIT 115: BUTANE TREATMENT AND DRYING FILTRATION SECTION PIPING AND INSTRUMENT DIA/GRAM								
DRAWING No.		PID-1718-115-0030-0103				REVISION		7

THIS DOCUMENT IS THE SOLE PROPERTY OF N.O.C. ALL INFORMATION CONTAINED HEREIN MAY NEITHER BE REPRODUCED
USED, DISCLOSED, TRANSMITTED OR IN ANY WAY MADE PUBLIC WITHOUT THE WRITTEN PERMISSION OF THE OWNER

ITEM 115-F-102
SERVICE C4 SAND GUARD FILTER
DESIGN PRESS 24.0 bar g
DESIGN TEMP 85°C

ITEM 115-E-102
SERVICE C4 MOLECULAR SIEVES FEED/EFFLUENT EXCHANGER
TYPE AEU OR BEU
DUTY /SURFACE 0.426 MW /20.1 m²
DESIGN PRESS SHELL 12.9 bar g TUBE 11.0 bar g
DESIGN TEMP 200°C 325°C
INSULATION H H

ITEM 115-H-101
SERVICE C4 MOLECULAR SIEVES REGENERATION ELECTRICAL HEATER
DUTY 504.2 kW
DESIGN PRESS 11.7 bar g
DESIGN TEMP 340°C

NOTES

- 1 - INSTRUMENTS AND CONTROL SYSTEM FOR EACH HEATER PASS WILL BE FINALIZED AFTER RECEIVING VENDOR DATA.
- 2 - RAMP OPERATION IS REQUIRED.
- 3 - VOTING SYSTEM. SD3 IS ACTIVATED BY AT LEAST TWO TSHH.
- 4 - TA-0021 LOW TEMPERATURE IS ALARM ONLY.
- 5 - FA-0021 HIGH FLOW IS ALARM ONLY.
- 6 - IF THE ADSORPTION PHASE END, BEFORE REGENERATION PHASE IS FINISHED, THESE QUENCH IS STOPPED AND UNIT 115 WILL BE SHUTDOWN.
- 7 - IN CASE OF HEATER TRIP, ALL VALVES IN REGENERATION CYCLE TO BE CLOSED.


HOLDS

- 1 - DELETED.
- 2 - DELETED.

GENERAL NOTES

ALL INSTRUMENT TAGS TO READ:
LETTERS NUMBER
1151 FFFF NNNN

DETAIL A (ON/OFF VALVE)

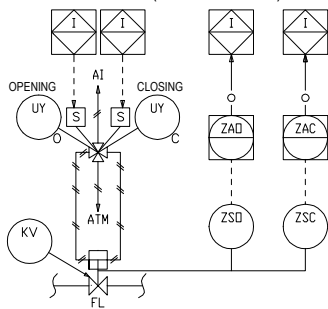

THIS P&ID IS BASED ON DRAWING NO. 115-SPD-4/6 SUPPLIED BY AXENS.

EQUIPMENT LIST

EXCHANGER	FILTER	HEATER
115-E-102	115-F-102	115-H-101

UTILITY PID NUMBER

FB17	PID-1718-186-0040-0004
DP	PID-1718-186-0040-0005

REV	DATE	DESCRIPTION	ORIG	PRPD	CHD	APP'D	AUTH'D
7	26/05/13	APPROVED FOR CONSTRUCTION					
6	07/05/12	APPROVED FOR CONSTRUCTION	OIEC	SM	MHM	SM	RM
5	28/11/10	APPROVED FOR CONSTRUCTION	OIEC	SM	MA	MMF	AAP
4	09/10/10	APPROVED FOR CONSTRUCTION	OIEC	SM	MA	MMF	AAP
3	22/12/09	APPROVED FOR DESIGN	OIEC	SM	MA	MMF	AAP
2	03/08/09	ISSUED FOR COMMENT	OIEC	SM	MA	MMF	AAP
1	28/11/08	APPROVED FOR DESIGN	WP	SH	AI	RPW	RC
0	08/09/08	ISSUED FOR HAZOP	WP	SH	AI	RPW	RC

SOUTH PARS GAS FIELD DEVELOPMENT PHASES 17&18
ASSALUYEH-IRAN
ONSHORE FACILITIES




PROJECT No: POGC-84-801-244

DOC. CLASS 1 SCALE: N/A



UNIT 115: BUTANE TREATMENT AND DRYING
BUTANE FILTRATION & REGENERATION ELECTRICAL HEATER
PIPING AND INSTRUMENT DIAGRAM

DRAWING No. PID-1718-115-0030-0104 REVISION 7

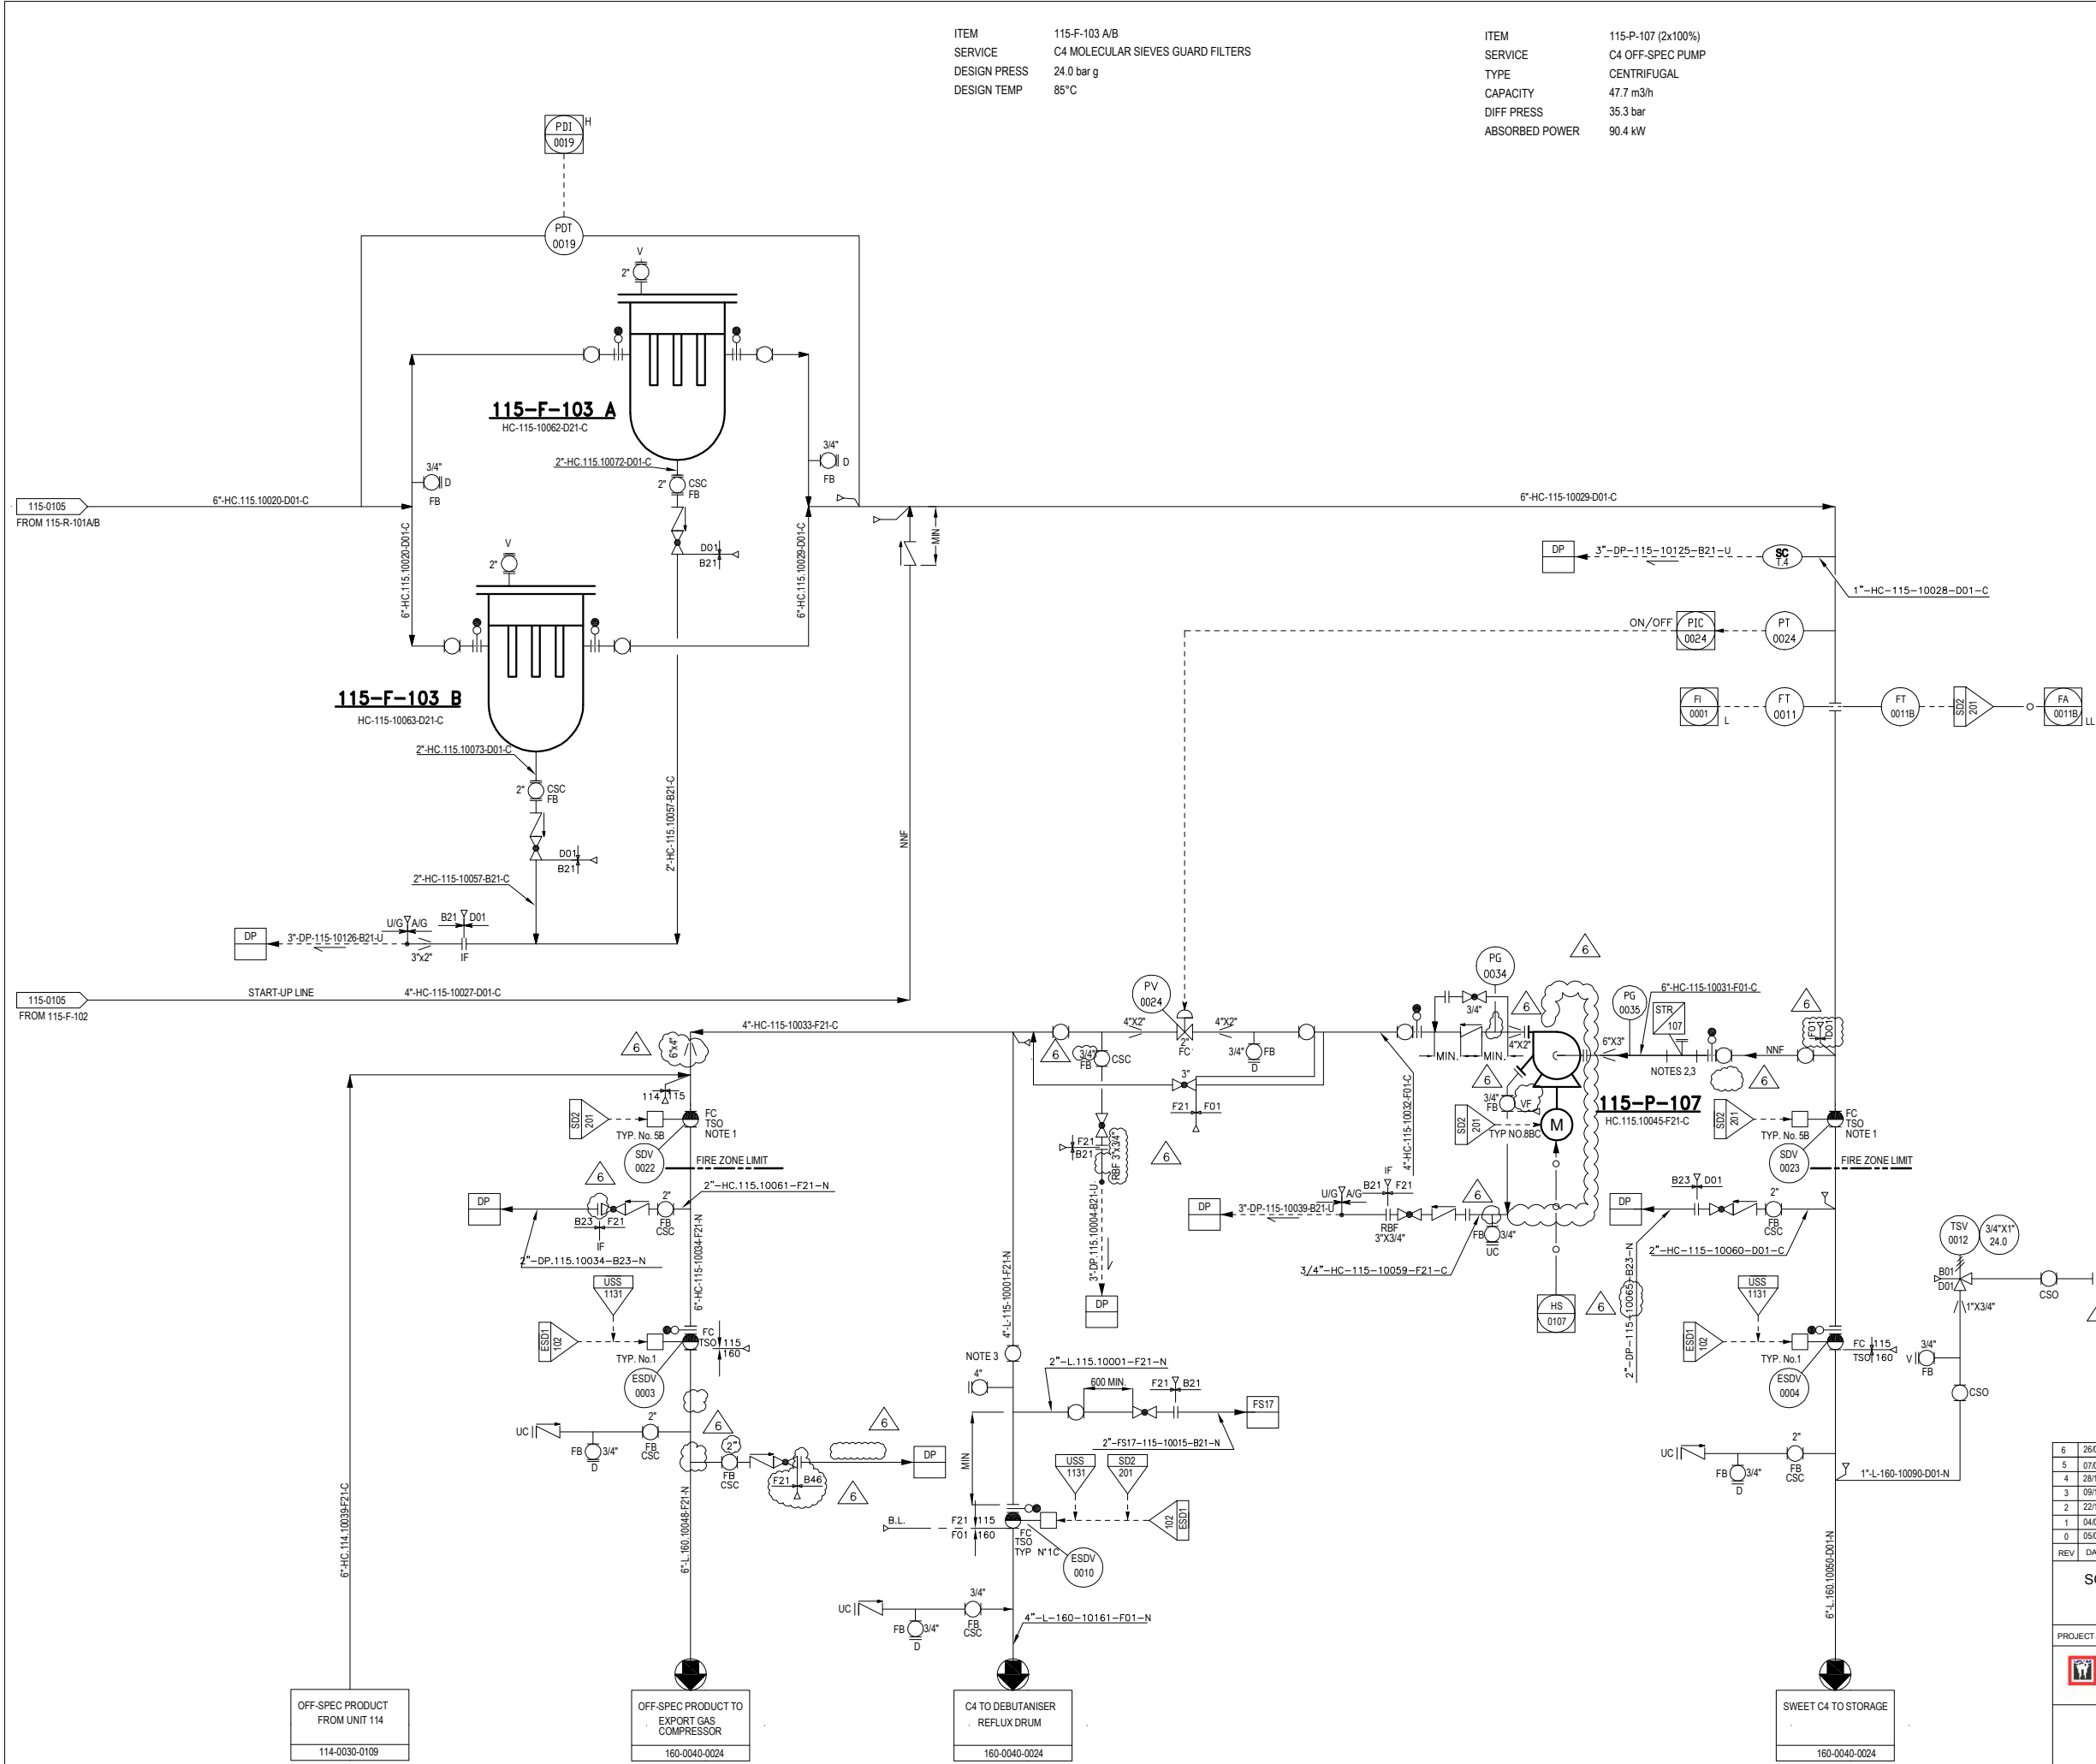

ITEM 115-F-103 A/B
SERVICE C4 MOLECULAR SIEVES GUARD FILTERS
DESIGN PRESS 24.0 bar g
DESIGN TEMP 85°C

ITEM 115-P-107 (2x100%)
SERVICE C4 OFF-SPEC PUMP
TYPE CENTRIFUGAL
CAPACITY 47.7 m3/h
DIFF PRESS 35.3 bar
ABSORBED POWER 90.4 kW

- NOTES
- 1 - FIRE RESISTANT VALVE (ALL INSTRUMENTS, BOX PROTECTION, TUBING, CABLES, ETC., WILL BE SELECTED AND CLASSIFIED ACCORDING TO THIS PROTECTION).
 - 2 - FOR FILTER ARRANGEMENT REFER TO TABLE 'A' ON PID-1718-999-0030-0006.
 - 3- SUCTION AND DISCHARGE CONNECTIONS ARE FOR STATR-UP.

GENERAL NOTES

ALL INSTRUMENT TAGS TO READ:
LETTERS NUMBER
1151 FFFF NNNN

- HOLDS
- 1- DELETED.
 - 2- DELETED.

THIS P&ID IS BASED ON DRAWING NO. 115-SPD-616 SUPPLIED BY AXENS.

EQUIPMENT LIST			
FILTER	PUMP		
115-F-103A/B	115-P-107		

UTILITY PID NUMBER	
DP	PID-1718-186-0040-0005
FS17	PID-1718-186-0040-0004

6	26/05/13	APPROVED FOR CONSTRUCTION	OIEC	SD	SM	SM	RM
5	07/05/12	APPROVED FOR CONSTRUCTION	OIEC	SM	MMH	SM	RM
4	28/11/10	APPROVED FOR CONSTRUCTION	OIEC	SM	MA	MMF	AAP
3	09/10/10	APPROVED FOR CONSTRUCTION	OIEC	SM	MA	MMF	AAP
2	22/12/09	APPROVED FOR DESIGN	OIEC	SM	MA	MMF	AAP
1	04/08/09	ISSUED FOR COMMENT	OIEC	SM	MA	MMF	AAP
0	05/09/08	ISSUED FOR HAZOP	WP	SH	AI	RPW	RC
REV	DATE	DESCRIPTION	ORIG	PRPD	CHD	APPD	AUTHD
SOUTH PARS GAS FIELD DEVELOPMENT PHASES 17&18 ASSALUYEH-IRAN ONSHORE FACILITIES							 POGC
PROJECT No: POGC-84-801-244			DOC CLASS		1	SCALE: N/A	
 WorleyParsons WORLDWIDE PROJECTS		 IDRO	 OIEC		 IOEC		
UNIT 115: BUTANE TREATMENT AND DRYING C4 PRODUCT EXPORT SECTION PIPING AND INSTRUMENT DIA/GRAM							
DRAWING No.		PID-1718-115-0030-0106				REVISION 6	

THIS DOCUMENT IS THE SOLE PROPERTY OF N.L.O.C. ALL INFORMATION CONTAINED HEREIN MAY NEITHER BE REPRODUCED NOR USED, DISCLOSED, TRANSMITTED OR IN ANY WAY MADE PUBLIC WITHOUT THE WRITTEN PERMISSION OF THE OWNER.

ITEM	115-D-102	ITEM	115-A-101
SERVICE	ADSORBERS DRAINING/FILLING DRUM	SERVICE	REGENERATION GAS CONDENSER
IDxTL-TL	2300mm x 6850mm	DUTY/SURFACE	0.334 MW/23 m ²
DESIGN PRESS	12.6/F.V. barg	DESIGN PRESS	10.7 bar g
DESIGN TEMP	85°C	DESIGN TEMP	200°C
INSULATION	YES	INSTALLED POWER	11 KW

ITEM	115-E-101
SERVICE	REGENERATION GAS TRIM COOLER
TYPE	DOUBLE PIPE
DUTY/SURFACE	0.066 MW/68 m ²
SHELL	TUBE
DESIGN PRESS	11.5 bar g
DESIGN TEMP	185°C
INSULATION	N

ITEM	115-D-103
SERVICE	REGENERATION K.O. DRUM
IDxTL-TL	750mm x 2300mm
DESIGN PRESS	9.1/F.V. barg
DESIGN TEMP	185°C
INSULATION	NO

NOTES

- 1- PRESENCE OF LPG. POSSIBILITY OF FREEZING VALVES IN CASE OF MISOPERATION MINIMUM DISTANCE BETWEEN TWO VALVES SHALL BE 600 mm.
- 2- VALVE EQUIPPED WITH AIR RESERVE.
- 3- FIRE RESISTANT VALVE (ALL INSTRUMENTS, BOX PROTECTION, TUBING, CABLES...ETC, WILL BE SELECTED AND CLASSIFIED ACCORDING TO THIS PROTECTION).
- 4- VALVE LOCATED AT HIGH POINT.
- 5- AIR RESERVE TO BE SIZED TO BE ABLE TO COMMAND FOR 3 STROKES VALVE OPERATING DURING AIR INSTRUMENT FAILURE.
- 6- FOR SAFETY REASON.
- 7- TWO PHASES FLOW LINE, NEED FOR REINFORCED ANCHORING.
- 8- PIC HAS TWO SET POINTS: ONE FOR DRAINING PHASE AND ONE FOR FILLING PHASE.
- 9- RISING STEM BALL VALVE.
- 10- NUMBER OF AIR COOLER BAYS IS 1.

GENERAL NOTES


ALL INSTRUMENT TAGS TO READ:
LETTERS NUMBER

1141 FFF NNNN

HOLDS


- 1- DELETED.
- 2- DELETED.
- 3- DELETED.

DETAIL A (ON/OFF VALVE)

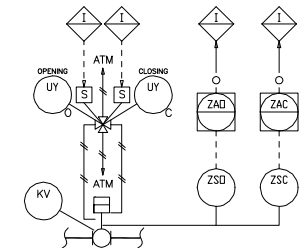

DETAIL B (RAMP OPENING VALVE)

A RAMP SHALL BE INSTALLED ON THE AIR CIRCUIT FOR OPENING POSITION. (CLOSED TO OPEN POSITION IN 2 MINUTES APPROXIMATELY)

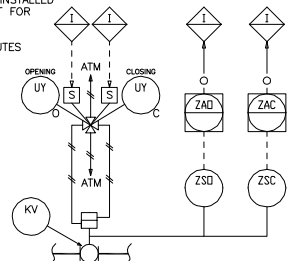

THIS P&ID IS BASED ON DRAWING NO. 115-SPD-7/8 SUPPLIED BY AXENS.

DRUM	EXCHANGER	AIR COOLER
115-D-102	115-E-101	115-A-101
115-D-103		

UTILITY PID NUMBER

FB17	PID-1718-186-0040-0004	FS17	PID-1718-186-0040-0004
SW	PID-1718-186-0040-0003	DS	PID-1718-186-0040-0005
DR	PID-1718-186-0040-0005		

6	26/05/13	APPROVED FOR CONSTRUCTION	OIEC	SD	SM	SM	RM
5	07/05/12	APPROVED FOR CONSTRUCTION	OIEC	SM	MHM	SM	RM
4	28/11/10	APPROVED FOR CONSTRUCTION	OIEC	SM	MA	MMF	AAP
3	09/10/10	APPROVED FOR CONSTRUCTION	OIEC	SM	MA	MMF	AAP
2	22/12/09	APPROVED FOR DESIGN	OIEC	SM	MA	MMF	AAP
1	04/08/09	ISSUED FOR COMMENT	OIEC	SM	MA	MMF	AAP
0	05/09/08	ISSUED FOR HAZOP	WP	SH	AJ	RPW	RC
REV	DATE	DESCRIPTION	ORIGI	PRPD	CHD	APPD	AUTHD


SOUTH PARS GAS FIELD DEVELOPMENT PHASES 17&18 ASSALUYEH-IRAN ONSHORE FACILITIES



PROJECT No: POGC-84-801-244	DOC. CLASS	1	SCALE:	N/A
WorleyParsons	IDRO	OIEC	IOEC	

UNIT 115: BUTANE TREATMENT AND DRYING REGENERATION COOLING SECTION PIPING AND INSTRUMENT DIAGRAM

DRAWING No.	PID-1718-115-0030-0107	REVISION	6
-------------	------------------------	----------	---

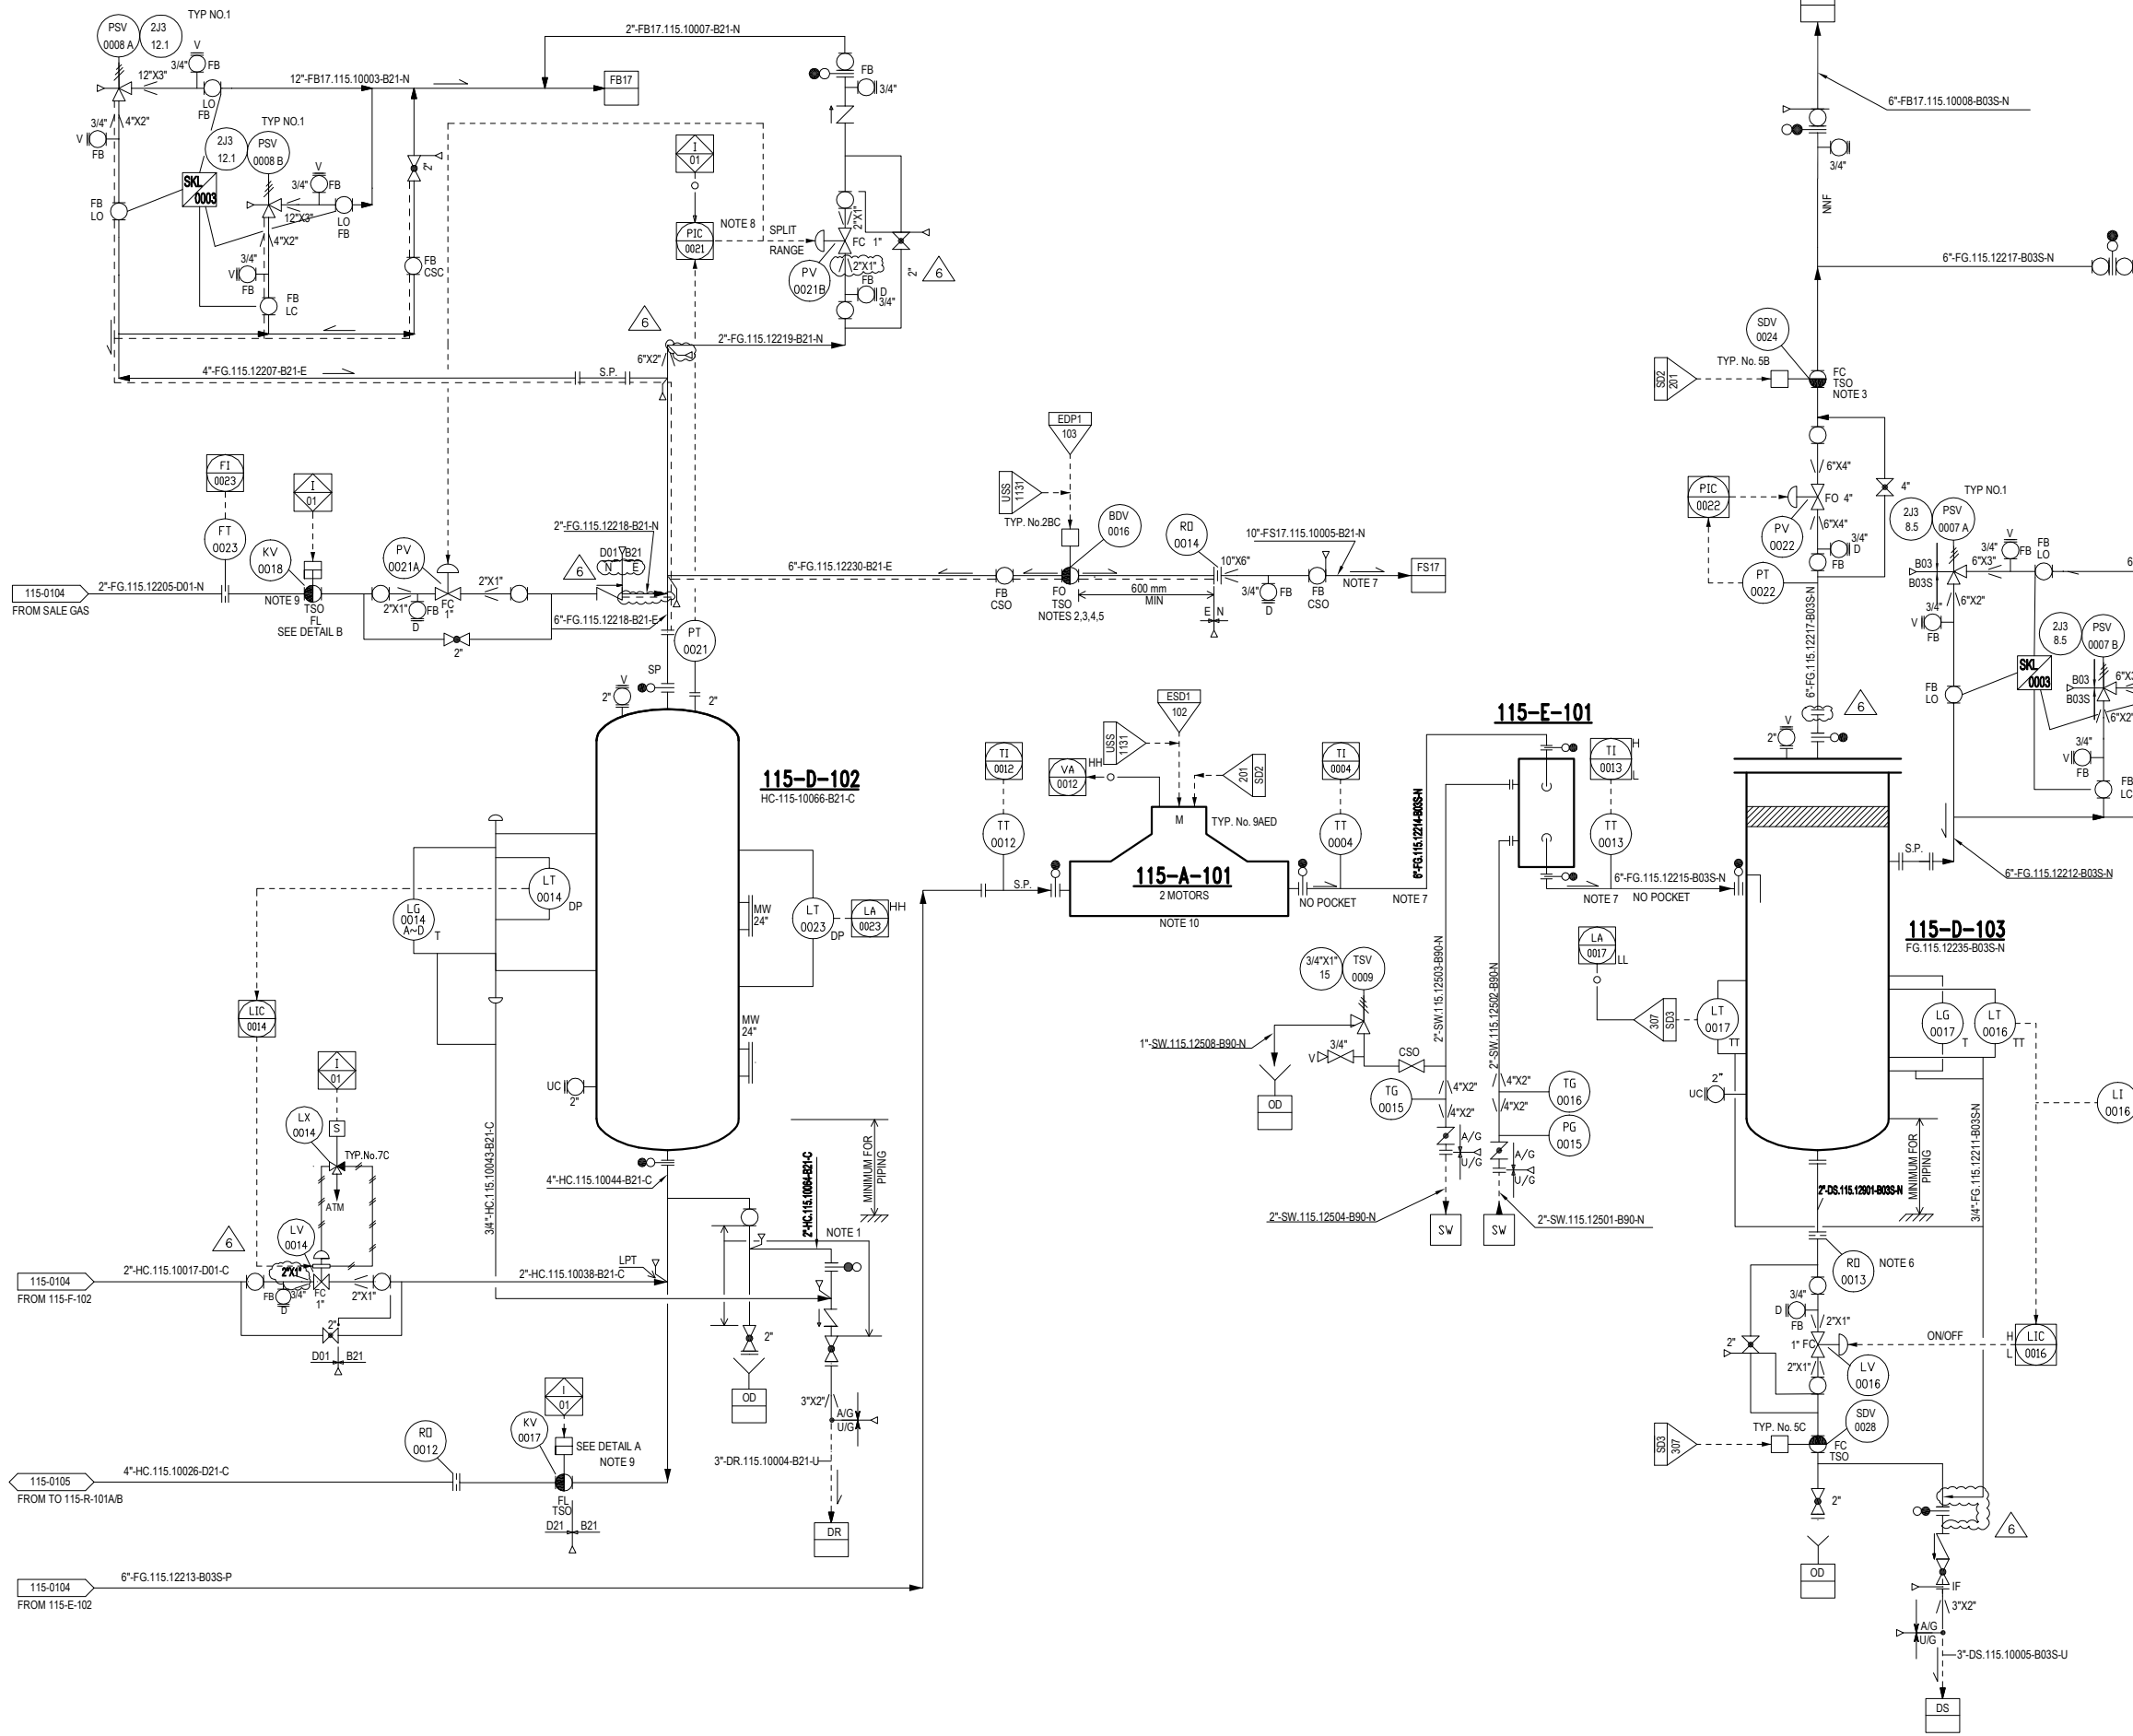

THIS DOCUMENT IS THE SOLE PROPERTY OF N.L.O.C. ALL INFORMATION CONTAINED HEREIN MAY NEITHER BE REPRODUCED, USED, DISCLOSED, TRANSMITTED OR IN ANY WAY MADE PUBLIC WITHOUT THE WRITTEN PERMISSION OF THE OWNER.

ITEM
SERVICE
TYPE
CAPACITY
DIFF. PRESS.
ABSORBED POWER

115-P-106 A/B (2x100%)
WATER CIRCULATION PUMPS
CENTRIFUGAL
91 m³/h
2.1 bar
1.7kw

ITEM
SERVICE
TYPE
DUTY/SURFACE
DESIGN. PRESS.
DESIGN. TEMP.
INSULATION

115-E-103
CAUSTIC RECYCLE HEATER
DOUBLE PIPE
0.347 MW/6.2 m²
SHELL TUBE
14.3barg 11.0 barg
85°C 270°C
H H

ITEM
SERVICE
TYPE
DESIGN. PRESS.
DESIGN. TEMP.
INSULATION

115-C-102
C4 CAUSTIC SCRUBBER
TOP:800mmx1200mm
BOTTOM:2400mmx3800mm
8.5 barg TOP/9.4 barg BOT/TV
85°C
YES

ITEM
SERVICE
TYPE
CAPACITY
DIFF. PRESS.
ABSORBED POWER

115-P-105 A/B (2x100%)
CAUSTIC CIRCULATION PUMPS
CENTRIFUGAL
13.6m³/h
3.5 bar
4.7KW

NOTES

- 1- OPERATOR SHOULD BE ABLE TO SWITCH FROM FUEL GAS TO FLARE DURING NORMAL OPERATION IN CASE OF SCRUBBER UPSET.
- 2- VALVE WITH MECHANICAL LIMIT STOP (IN ORDER TO AVOID FULL CLOSURE OF VALVE)
- 3- INSTRUMENT SHALL BE SELF-DRAINING.
- 4- HLL MUST BE DEFINED AT CHIMNEY TOP. TOWER WILL BE OPERATED UNDER AT HLL/HIGH LIQUID LEVEL.
- 5- LI TO BE READABLE FROM GLOBE VALVE ON DEMINERALIZED WATER.
- 6- FOR CAUSTIC INVENTORY REMOVAL OPERATION.
- 7- DELETED.
- 8- NO STEAM-OUT IS ALLOWED IF CAUSTIC SODA IS NOT PROPERLY REMOVED FROM SCRUBBER.
- 9- FOR HC PHASE DRAINING SKIMMING.
- 10- FOR FILTER ARRANGEMENT REFER TO TABLE "A" ON PID-1718-999-0030-0006.
- 11- STEAM TRAP.
- 12- FIRE RESISTANT VALVE (ALL INSTRUMENTS, BOX PROTECTION, TUBING, CABLES, ETC., WILL BE SELECTED AND CLASSIFIED ACCORDING TO THIS PROTECTION).
- 13- ON LOW LOW FLOW DUTY PUMP IS STOPPED AND STANDBY PUMP STARTED IF AFTER 30 SECONDS FLOW REMAINS LOW, PUMPS ARE TRIPPED.
- 14- DISTANCE TO BE MINIMIZED.
- 15- A RAMP SHALL BE INSTALLED ON THE AIR CIRCUIT FOR OPENING AND CLOSING POSITIONS (CLOSE TO OPEN TO CLOSE IN 2 MINUTES APPROXIMATELY. OPENING AND CLOSING TIME BE TUNABLE IN ORDER TO BE ADJUSTED ON SITE.)
- 16- RISING STEM BALL VALVE.
- 17- DRIP LEG. FOR DETAIL "A" REFER TO PID-1718-186-0040-0001.


HOLDS

- 1-DELETED.
- 2-DELETED.
- 3-DELETED.

GENERAL NOTES

ALL INSTRUMENT TAGS TO READ:
LETTERS NUMBER
1151 FFF NNNN

DETAIL "B"

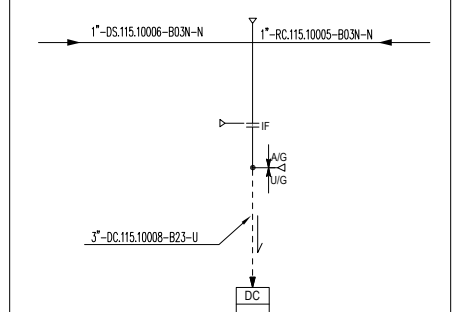

THIS P&ID IS BASED ON DRAWING NO. 115-SPD-818 SUPPLIED BY AXENS.

EQUIPMENT LIST

COLUMN	PUMPS	EXCHANGER
115-C-102	115-P-105A/B 115-P-106A/B	115-E-103

UTILITY PID NUMBER

DC	PID-1718-186-0040-0005	SL	PID-1718-186-0040-0001
DR	PID-1718-186-0040-0005	CL	PID-1718-186-0040-0001
FB17	PID-1718-186-0040-0004		
SC	PID-1718-186-0040-0005		

REV	DATE	DESCRIPTION	ORIGI	PRP'D	CH'D	AP'D	AUTH'D
6	26/05/13	APPROVED FOR CONSTRUCTION	OIEC	SD	SM	SM	RM
5	07/05/12	APPROVED FOR CONSTRUCTION	OIEC	SM	MHM	SM	RM
4	28/11/10	APPROVED FOR CONSTRUCTION	OIEC	SM	MA	MMF	AAP
3	09/10/10	APPROVED FOR CONSTRUCTION	OIEC	SM	MA	MMF	AAP
2	22/12/09	APPROVED FOR DESIGN	OIEC	SM	MA	MMF	AAP
1	04/08/09	ISSUED FOR COMMENT	OIEC	SM	MA	MMF	AAP
0	06/09/08	ISSUED FOR HAZOP	WP	SH	AI	RPW	RC

SOUTH PARS GAS FIELD DEVELOPMENT
PHASES 17&18 ASSALUYEH-IRAN
ONSHORE FACILITIES



PROJECT No: POGC-84-801-244

DOC. CLASS

1

SCALE:

N/A




DRAWING No. UNIT 115: BUTANE TREATMENT AND DRYING
CAUSTIC SCRUBBER
PIPING AND INSTRUMENT DIAGRAM

PID-1718-115-0030-0108

REVISION 6

THIS DOCUMENT IS THE SOLE PROPERTY OF N.L.O.C. ALL INFORMATION CONTAINED HEREIN MAY NEITHER BE REPRODUCED, USED, DISCLOSED, TRANSMITTED OR IN ANY WAY MADE PUBLIC WITHOUT THE WRITTEN PERMISSION OF THE OWNER.

ITEM 115-C-201
SERVICE C4 EXTRACTOR
IDxTL-TL (mm x mm) 1700X18700
DESIGN PRESS 24.0/FV barg
DESIGN TEMP 85°C
INSULATION YES

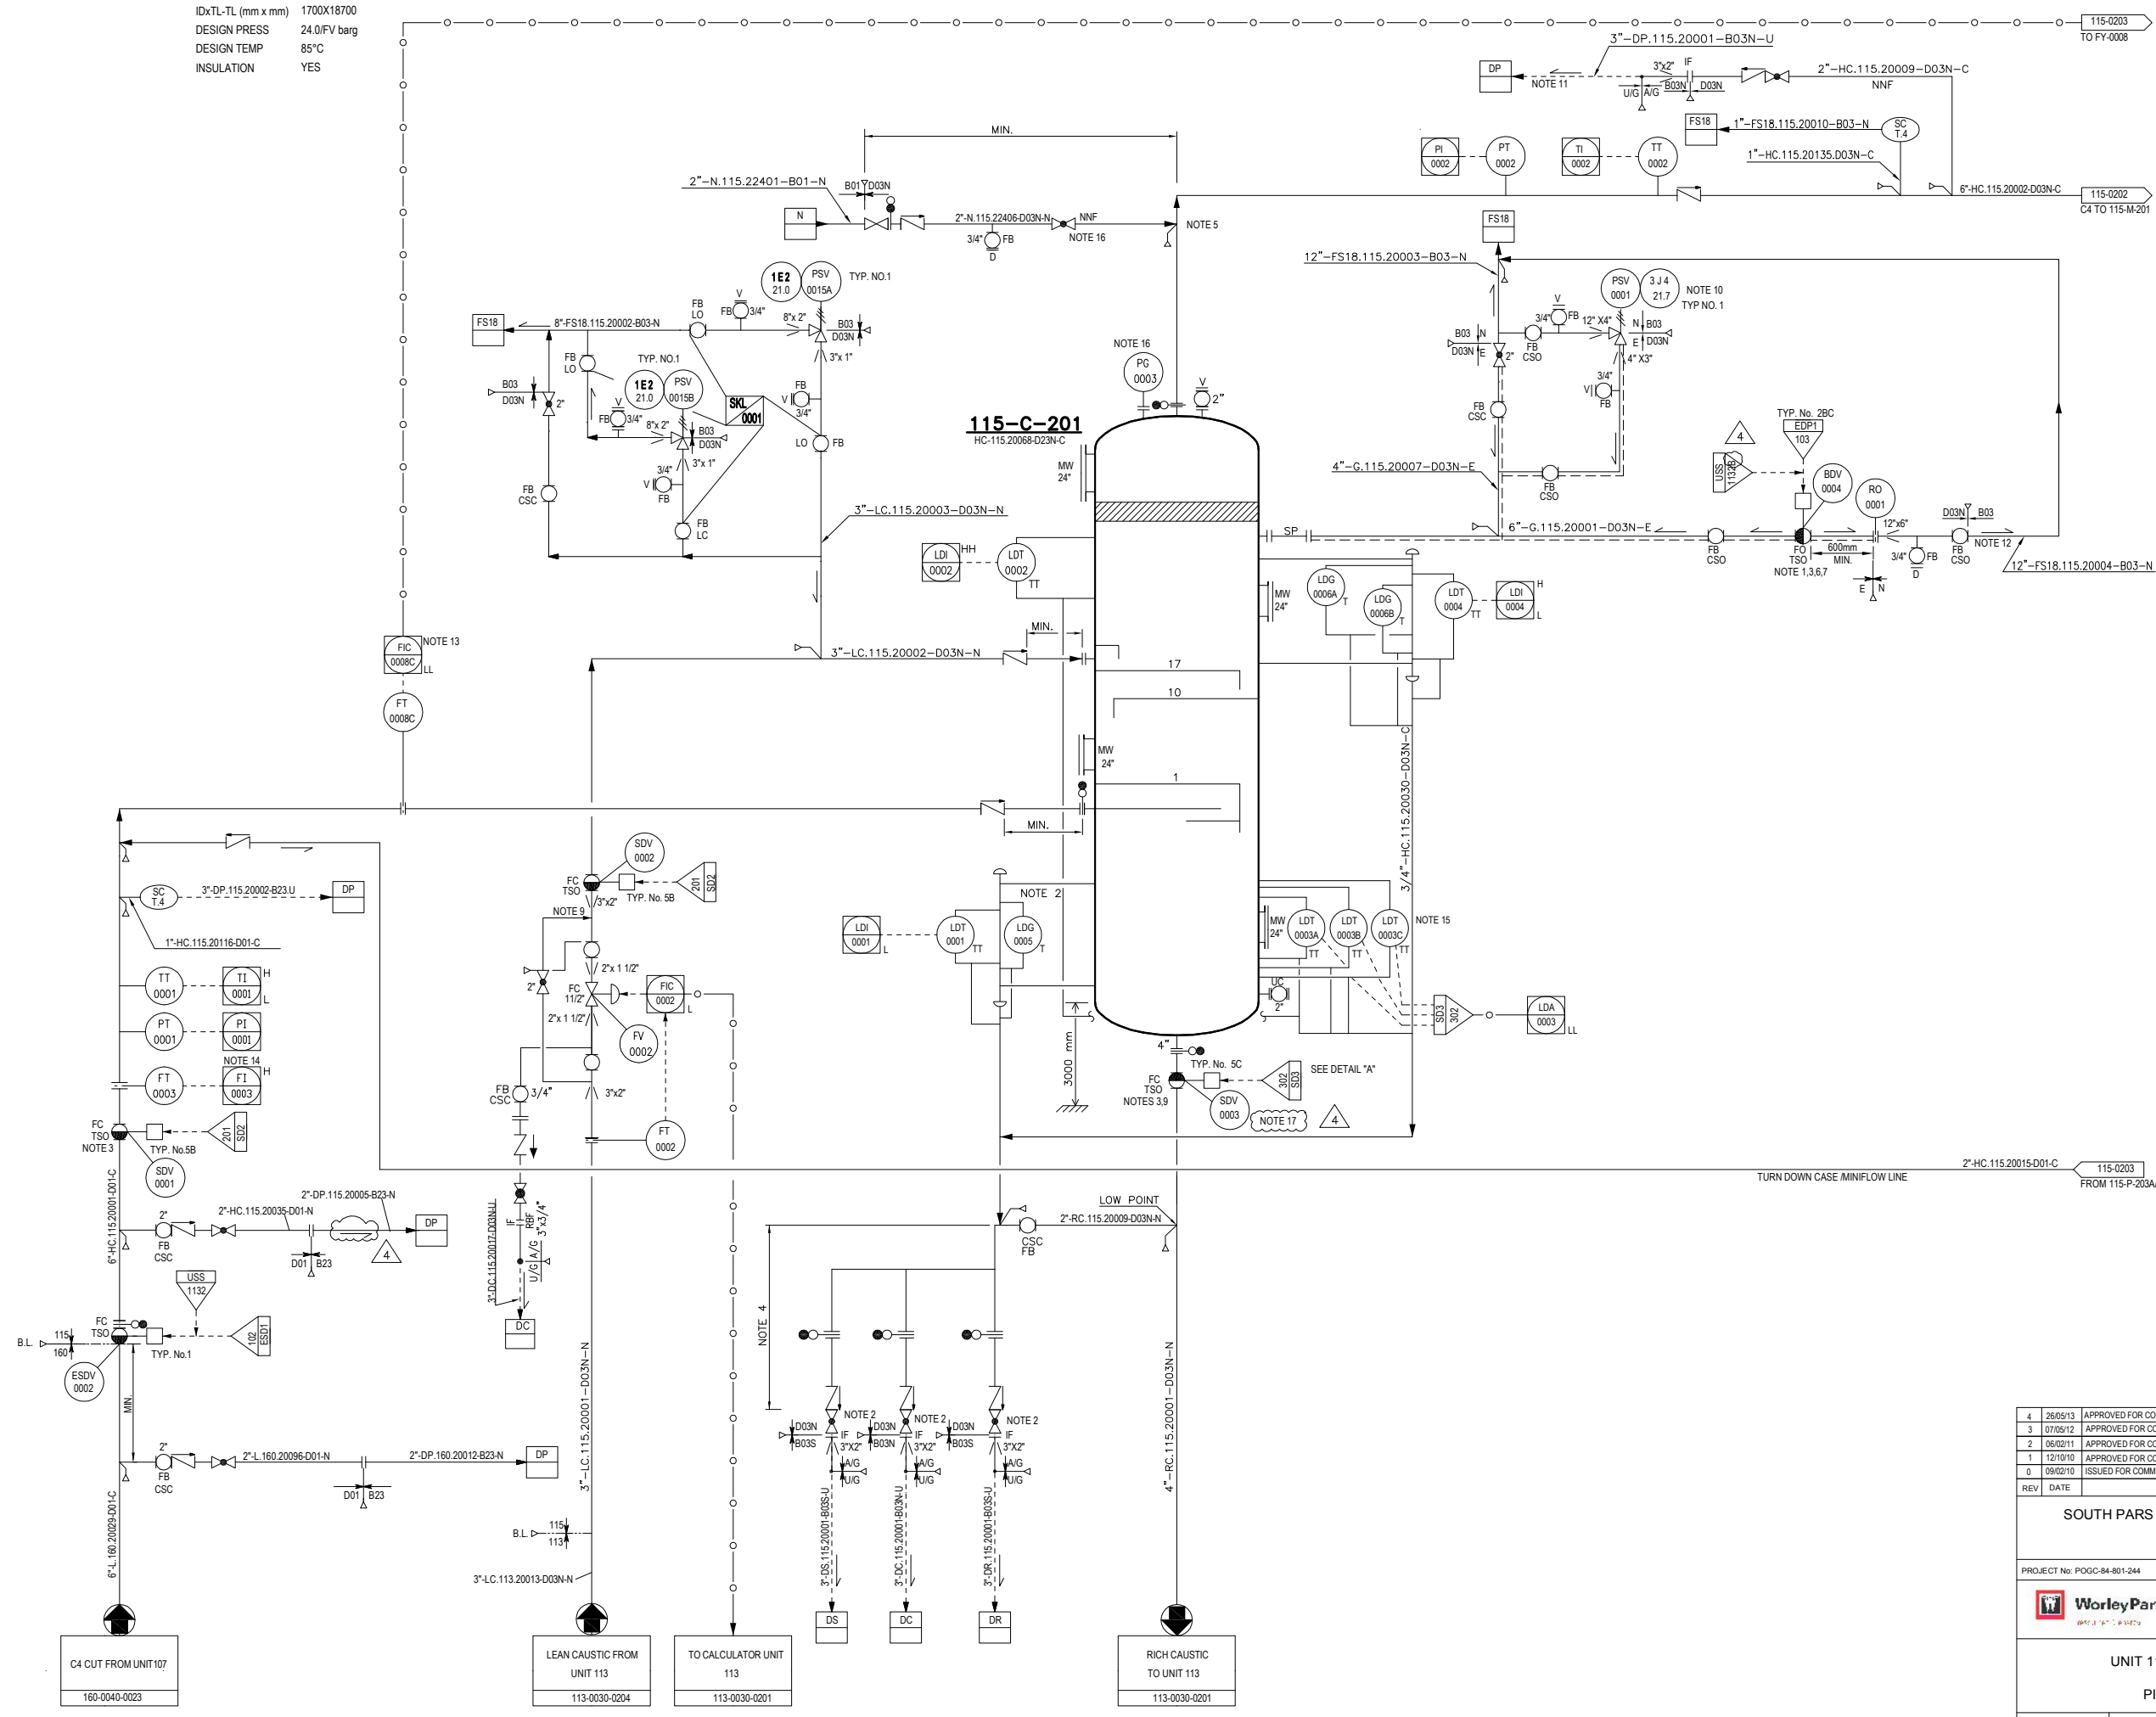


- NOTES**
- 1 - VALVE EQUIPPED WITH AIR RESERVE.
 - 2 - LDG ON 115-C-201 READABLE FROM SPENT CAUSTIC DRAINAGE VALVE FACILITIES.
 - 3 - FIRE RESISTANT VALVE (ALL INSTRUMENTS, BOX PROTECTION, TUBING, CABLES, ETC., WILL BE SELECTED AND CLASSIFIED ACCORDING TO THIS PROTECTION).
 - 4 - PRESENCE OF LPG. POSSIBILITY OF FREEZING VALVES IN CASE OF MISOPERATION. MINIMUM DISTANCE BETWEEN 2 VALVES SHALL BE 600 mm.
 - 5 - CONNECTION ON TOP OF THE LINE.
 - 6 - VALVE LOCATED AT HIGH POINT.
 - 7 - AIR RESERVE TO BE SIZED TO BE ABLE TO COMMAND FOR 3 STROKES VALVE OPERATING DURING AIR INSTRUMENT FAILURE.
 - 8 - DELETED.
 - 9 - ISOLATION VALVE TO BE LOCATED AT MINIMUM DISTANCE FROM 115-C-201.
 - 10 - SPARE RELIEF VALVE STORED IN WAREHOUSE.
 - 11 - LINE USED FOR DRAINING NON CONDENSABLE GASES.
 - 12 - TWO PHASES FLOW LINE NEED FOR REINFORCED ANCHORING.
 - 13 - IN CASE OF LOW FLOW ALARM, OPERATOR TO START 115-P-203.
 - 14 - IN CASE OF HIGH FLOW ALARM, OPERATOR TO STOP 115-P-203.
 - 15 - PROVIDE 2 OUT OF 3 VOTING SYSTEM.
 - 16 - PG 0003 TO BE READABLE FROM GLOBE VALVE.
 - 17 - LAHH-0004 A/B/C IN UNIT 113 INITIATE CLOSURE OF SDV-0003.

GENERAL NOTES

ALL INSTRUMENT TAGS TO READ:
LETTERS NUMBER
1152 FFFF NNNN

- HOLDS**
- 1 - DELETED.
 - 2 - DELETED.

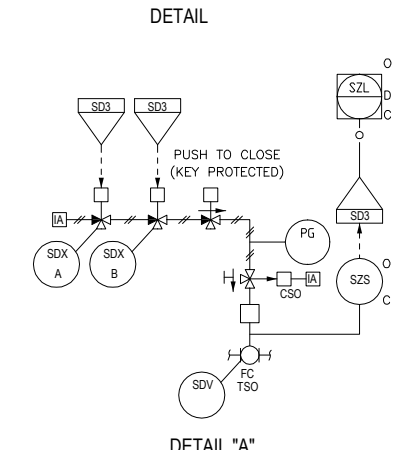

THIS P&ID IS BASED ON DRAWING NO. 115-SPD-1/8 SUPPLIED BY AXENS.

EQUIPMENT LIST			
COLUMN			
115-C-201			

UTILITY PID NUMBER			
FS18	PID-1718-186-0040-0204	DR	PID-1718-186-0040-0205
DC	PID-1718-186-0040-0205	DP	PID-1718-186-0040-0205
DS	PID-1718-186-0040-0205		
N	PID-1718-186-0040-0202		

REV	DATE	DESCRIPTION	ORIGI	PRP'D	CH'D	APP'D	AUTH'D
4	26/05/13	APPROVED FOR CONSTRUCTION	OIEC	SD	SM	SM	RM
3	07/05/12	APPROVED FOR CONSTRUCTION	OIEC	SM	MHM	SM	RM
2	06/02/11	APPROVED FOR CONSTRUCTION	OIEC	SM	MA	MMF	AAP
1	12/10/10	APPROVED FOR CONSTRUCTION	OIEC	SM	MA	MMF	AAP
0	09/02/10	ISSUED FOR COMMENT	OIEC	SM	MA	MMF	AAP

SOUTH PARS GAS FIELD DEVELOPMENT PHASES 17&18
ASSALUYEH-IRAN
ONSHORE FACILITIES

PROJECT No: POGC-84-801-244

DOC. CLASS 1 SCALE: N/A

WorleyParsons **IDRO** **OIEC** **IOEC**

UNIT 115: BUTANE TREATMENT AND DRYING - PHASE 18
C4 EXTRACTOR (TRAIN 2)
PIPING AND INSTRUMENT DIAGRAM

DRAWING No. PID-1718-115-0030-0201 REVISION 4

ITEM 115-D-201
SERVICE C4 WATER WASH DRUM
IDXTL.TL 2300 mm X 9200 mm
DESIGN PRESSURE 24.0 /FV barg
DESIGN TEMPERATURE 85°C
INSULATION YES

ITEM 115-P-201 A/B (2x100%)
SERVICE C4 WATER CIRCULATION PUMPS
TYPE CENTRIFUGAL
CAPACITY 10.0 m³/h
DIFFERENTIAL PRESSURE 3.8 bar
ABSORBED POWER 3.3 kW

ITEM 115-M-201
SERVICE C4 EXTRACTOR STATIC MIXER
DESIGN PRESSURE 24.0 bar g
DESIGN TEMPERATURE 85°C

ITEM 115-P-204 A/B (2x100%)
SERVICE C4 WATER MAKE-UP PUMPS
TYPE RECIPROCATING
CAPACITY 0.2 m³/h
DIFFERENTIAL PRESSURE 3.5 bar
ABSORBED POWER 3 kW

NOTES

- LDG ON 115-D-201 TO BE READABLE FROM GLOBE VALVES, ON VESSEL DRAINS.
- BY-PASS FOR C4 WATER WASH DRUM FILLING DURING START-UP.
- LINE TO BE DRAINABLE TO 115-D-201 OR TO 115-F-201 TO AVOID WATER ACCUMULATION IN LOW POINTS.
- VALVE EQUIPPED WITH AIR RESERVE.
- FIRE RESISTANT VALVE (ALL INSTRUMENTS, BOX PROTECTION, TUBING, CABLES, ETC. WILL BE SELECTED AND CLASSIFIED ACCORDING TO THIS PROTECTION).
- DELETED.
- CONNECTION ON TOP OF THE LINE.
- PRESERVE OF LPG, POSSIBILITY OF FREEZING VALVES IN CASE OF MISOPERATION. MINIMUM DISTANCE BETWEEN 2 VALVES SHALL BE 600 mm.
- SPARE RELIEF VALVES STORED IN WAREHOUSE.
- VALVE LOCATED AT HIGH POINT.
- AIR RESERVE TO BE SIZED TO BE ABLE TO COMMAND FOR 3 STROKES VALVE OPERATING DURING AIR INSTRUMENT FAILURE.
- DELETED.
- TO BE LOCATED FAR FROM PUMPS. FLOWRATE IS ADJUSTED MANUALLY
- ISOLATION VALVE TO BE LOCATED AT MINIMUM DISTANCE FROM 115-D-201.
- TWO PHASES FLOW LINES, NEED FOR REINFORCED ANCHORING.
- FOR FILTER ARRANGEMENT REFER TO TABLE "A" ON PID-1718-999-0030-0006
- ON LOW FLOW DUTY PUMP IS STOPPED AND STANDBY PUMP STARTED.
IF AFTER 30 SECONDS FLOW REMAINS LOW LOW, BOTH PUMPS ARE TRIPPED.
- LAHH-0008 IS ALARM ONLY.
- SDV-0005 CLOSED INDICATION TRIPS C4 WATER CIRCULATION PUMPS
- 115-P-201A/B WHEN RUNNING.
- PSV, PULSATION DAMPENER AND ALL OTHER REQUIRED ACCESSORIES (AS PER PROJECT SPECIFICATION) SHALL BE SUPPLIED BY PUMP VENDOR.

GENERAL NOTES

ALL INSTRUMENT TAGS TO READ:
LETTERS NUMBER
1152 FFFF NNNN

HOLDS

- DELETED.
- DELETED.
- DELETED.

THIS P&ID IS BASED ON DRAWING NO. 115-SPD-26 SUPPLIED BY AXENS.

EQUIPMENT LIST

DRUM	MIXER	PUMPS
115-D-201	115-M-201	115-P-201A/B 115-P-204A/B

UTILITY PID NUMBER

DC	PID-1718-186-0040-0205
DR	PID-1718-186-0040-0205
FS18	PID-1718-186-0040-0204
SC	PID-1718-186-0040-0205

REV	DATE	DESCRIPTION	ORIGI	PRPD	CHD	APP'D	AUTH'D
4	26/05/13	APPROVED FOR CONSTRUCTION	OIEC	SD	SM	SM	RM
3	07/05/12	APPROVED FOR CONSTRUCTION	OIEC	SM	MMH	SM	RM
2	06/02/11	APPROVED FOR CONSTRUCTION	OIEC	SM	MA	MMF	AAP
1	12/10/10	APPROVED FOR CONSTRUCTION	OIEC	SM	MA	MMF	AAP
0	09/02/10	ISSUED FOR COMMENT	OIEC	SM	MA	MMF	AAP

SOUTH PARS GAS FIELD DEVELOPMENT PHASES 17&18
ASSALUYEH-IRAN
ONSHORE FACILITIES



PROJECT No: POGC-84-801-244

DOC. CLASS

1

SCALE:


N/A



UNIT 115: BUTANE TREATMENT AND DRYING - PHASE 18
WATER WASH DRUM (TRAIN 2)
PIPING AND INSTRUMENT DIA/GRAM

DRAWING No. PID-1718-115-0030-0202


REVISION 4

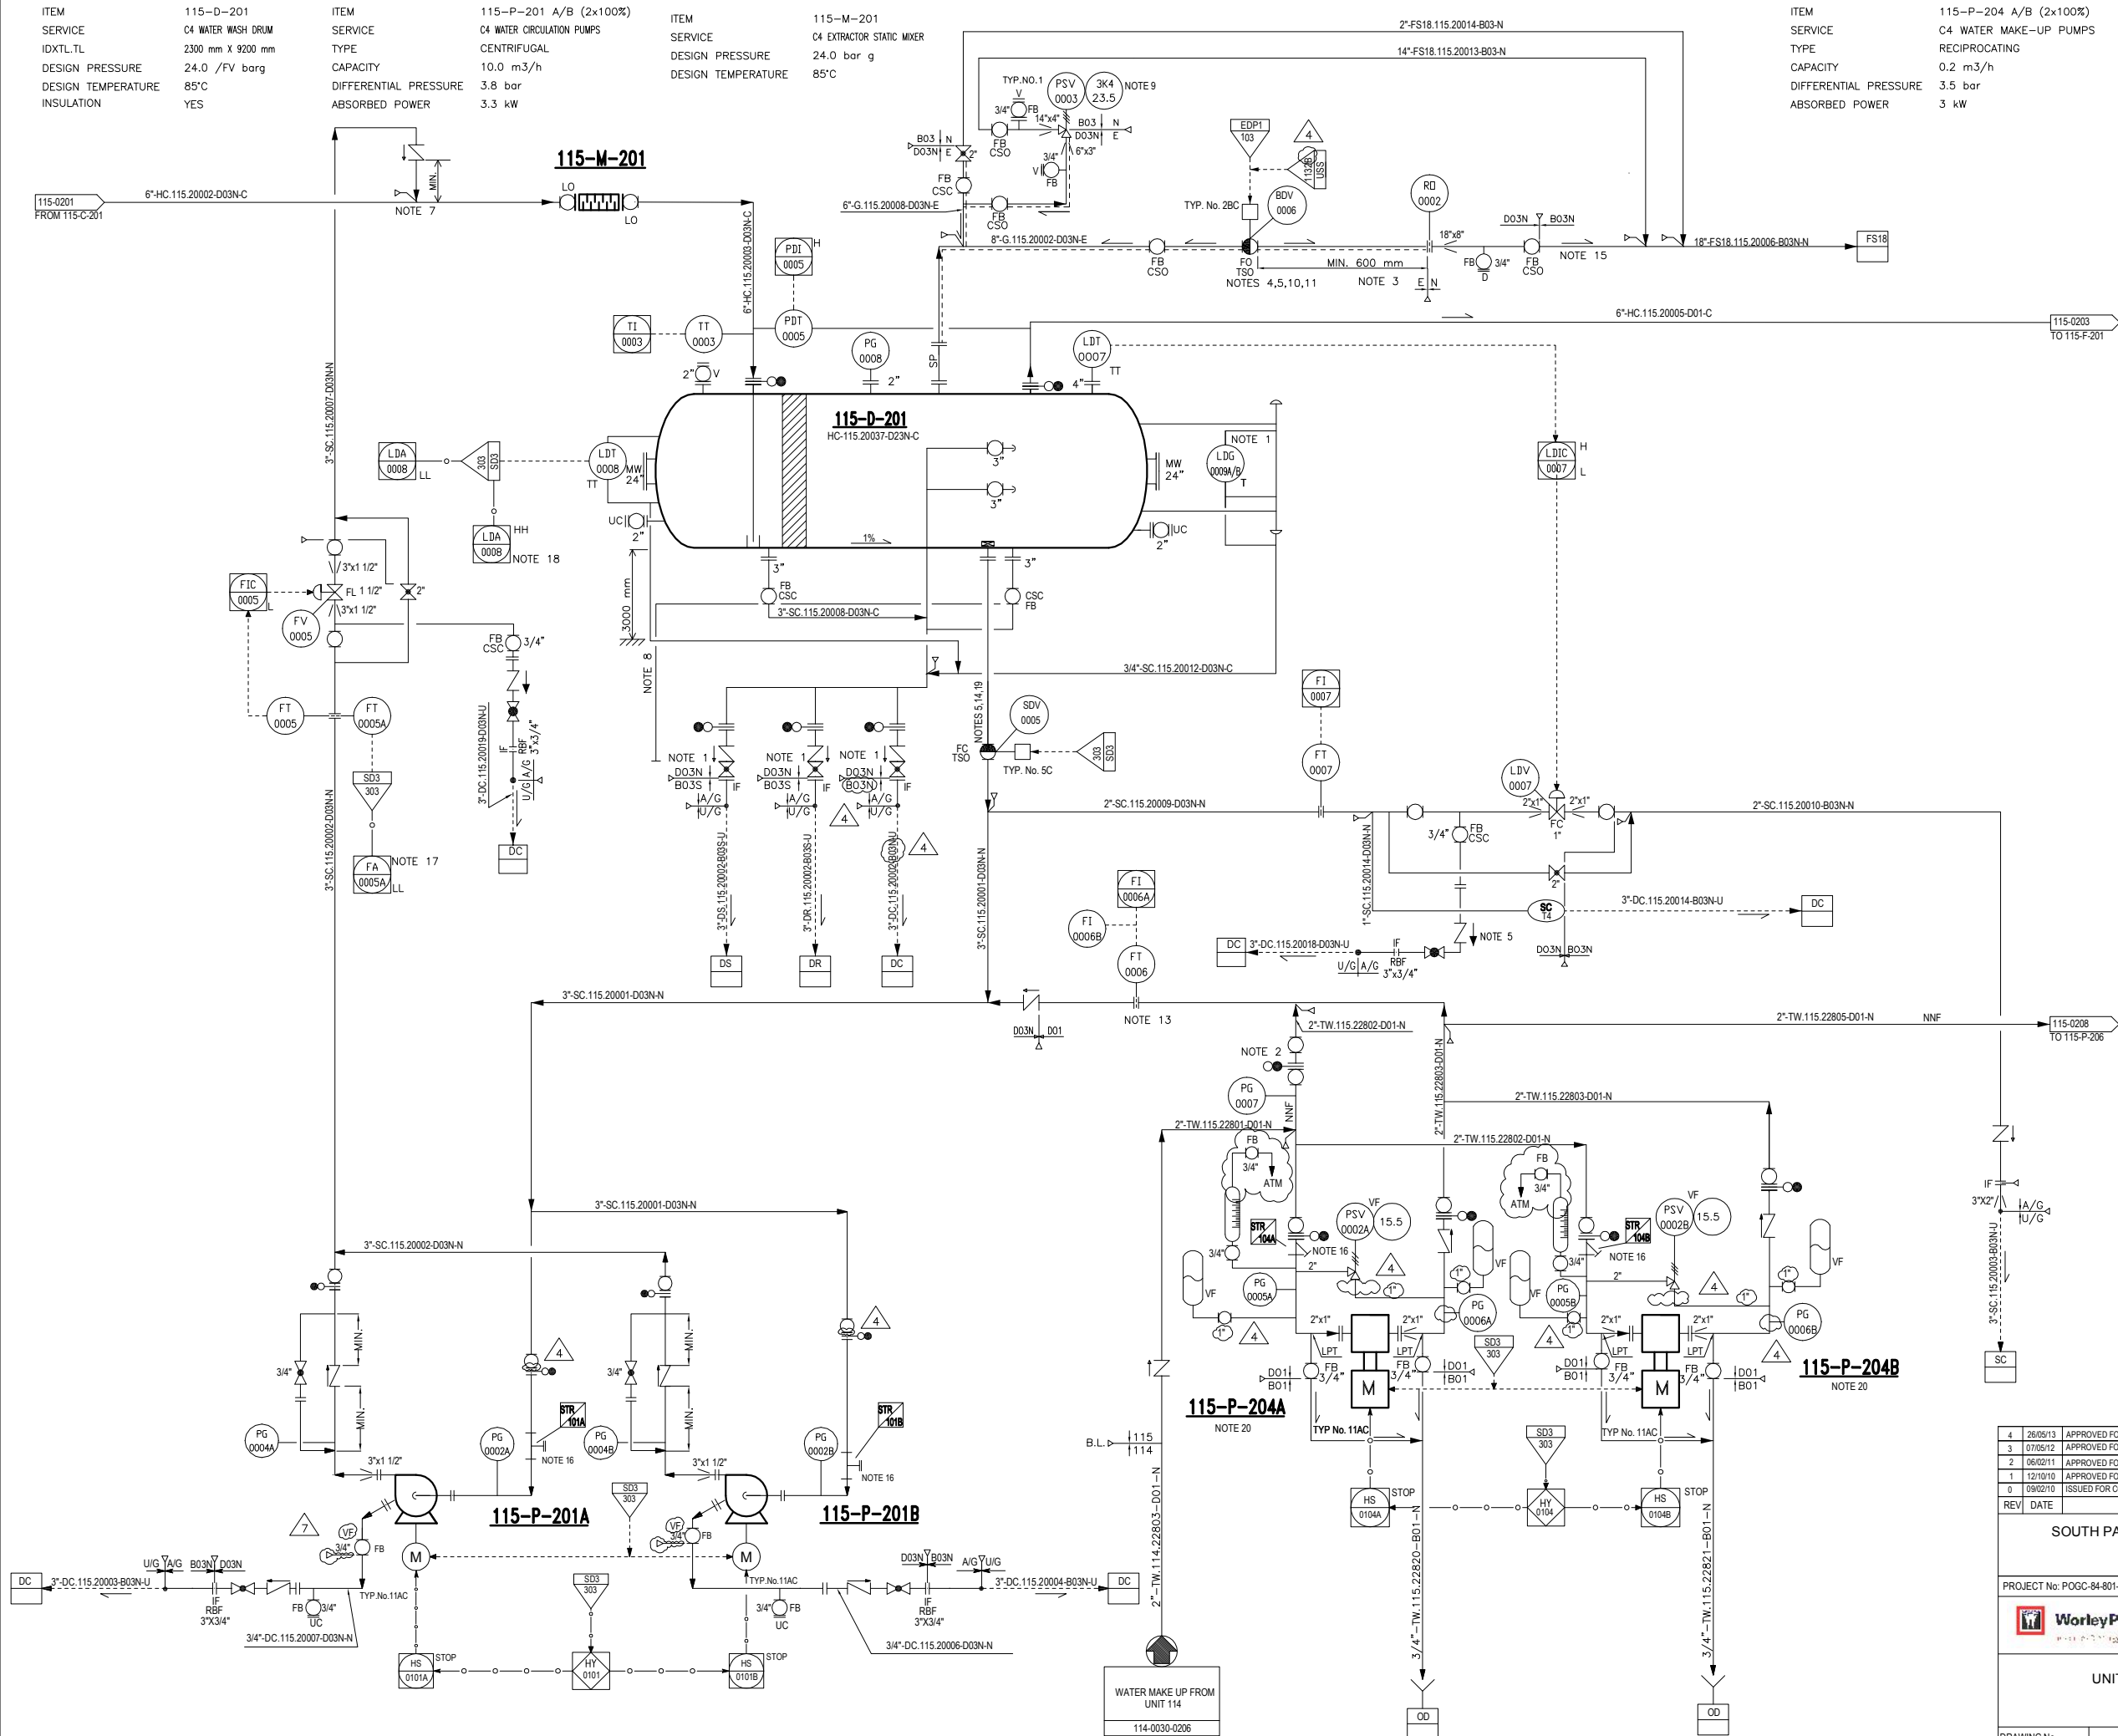

ITEM 115-P-202 A/B (2x100%)
SERVICE SWEET C4 PUMPS
TYPE RECIPROCATING
CAPACITY 3.1 m3/h
DIFF. PRESS. 26.4 bar
ABSORBED POWER 3.7 kW

ITEM 115-F-201
SERVICE C4 SAND FILTER
TYPE IDxTL-TL
DESIGN PRESS 2200 mm x 4850 mm
DESIGN TEMP 24.0/ F.V. barg
INSULATION 85°C
YES

ITEM 115-P-203
SERVICE C4 TURNDOWN PUMP
TYPE CENTRIFUGAL
CAPACITY 10.3 m3/h
DIFF. PRESS 6.4 bar
ABSORBED POWER 12.1 kW

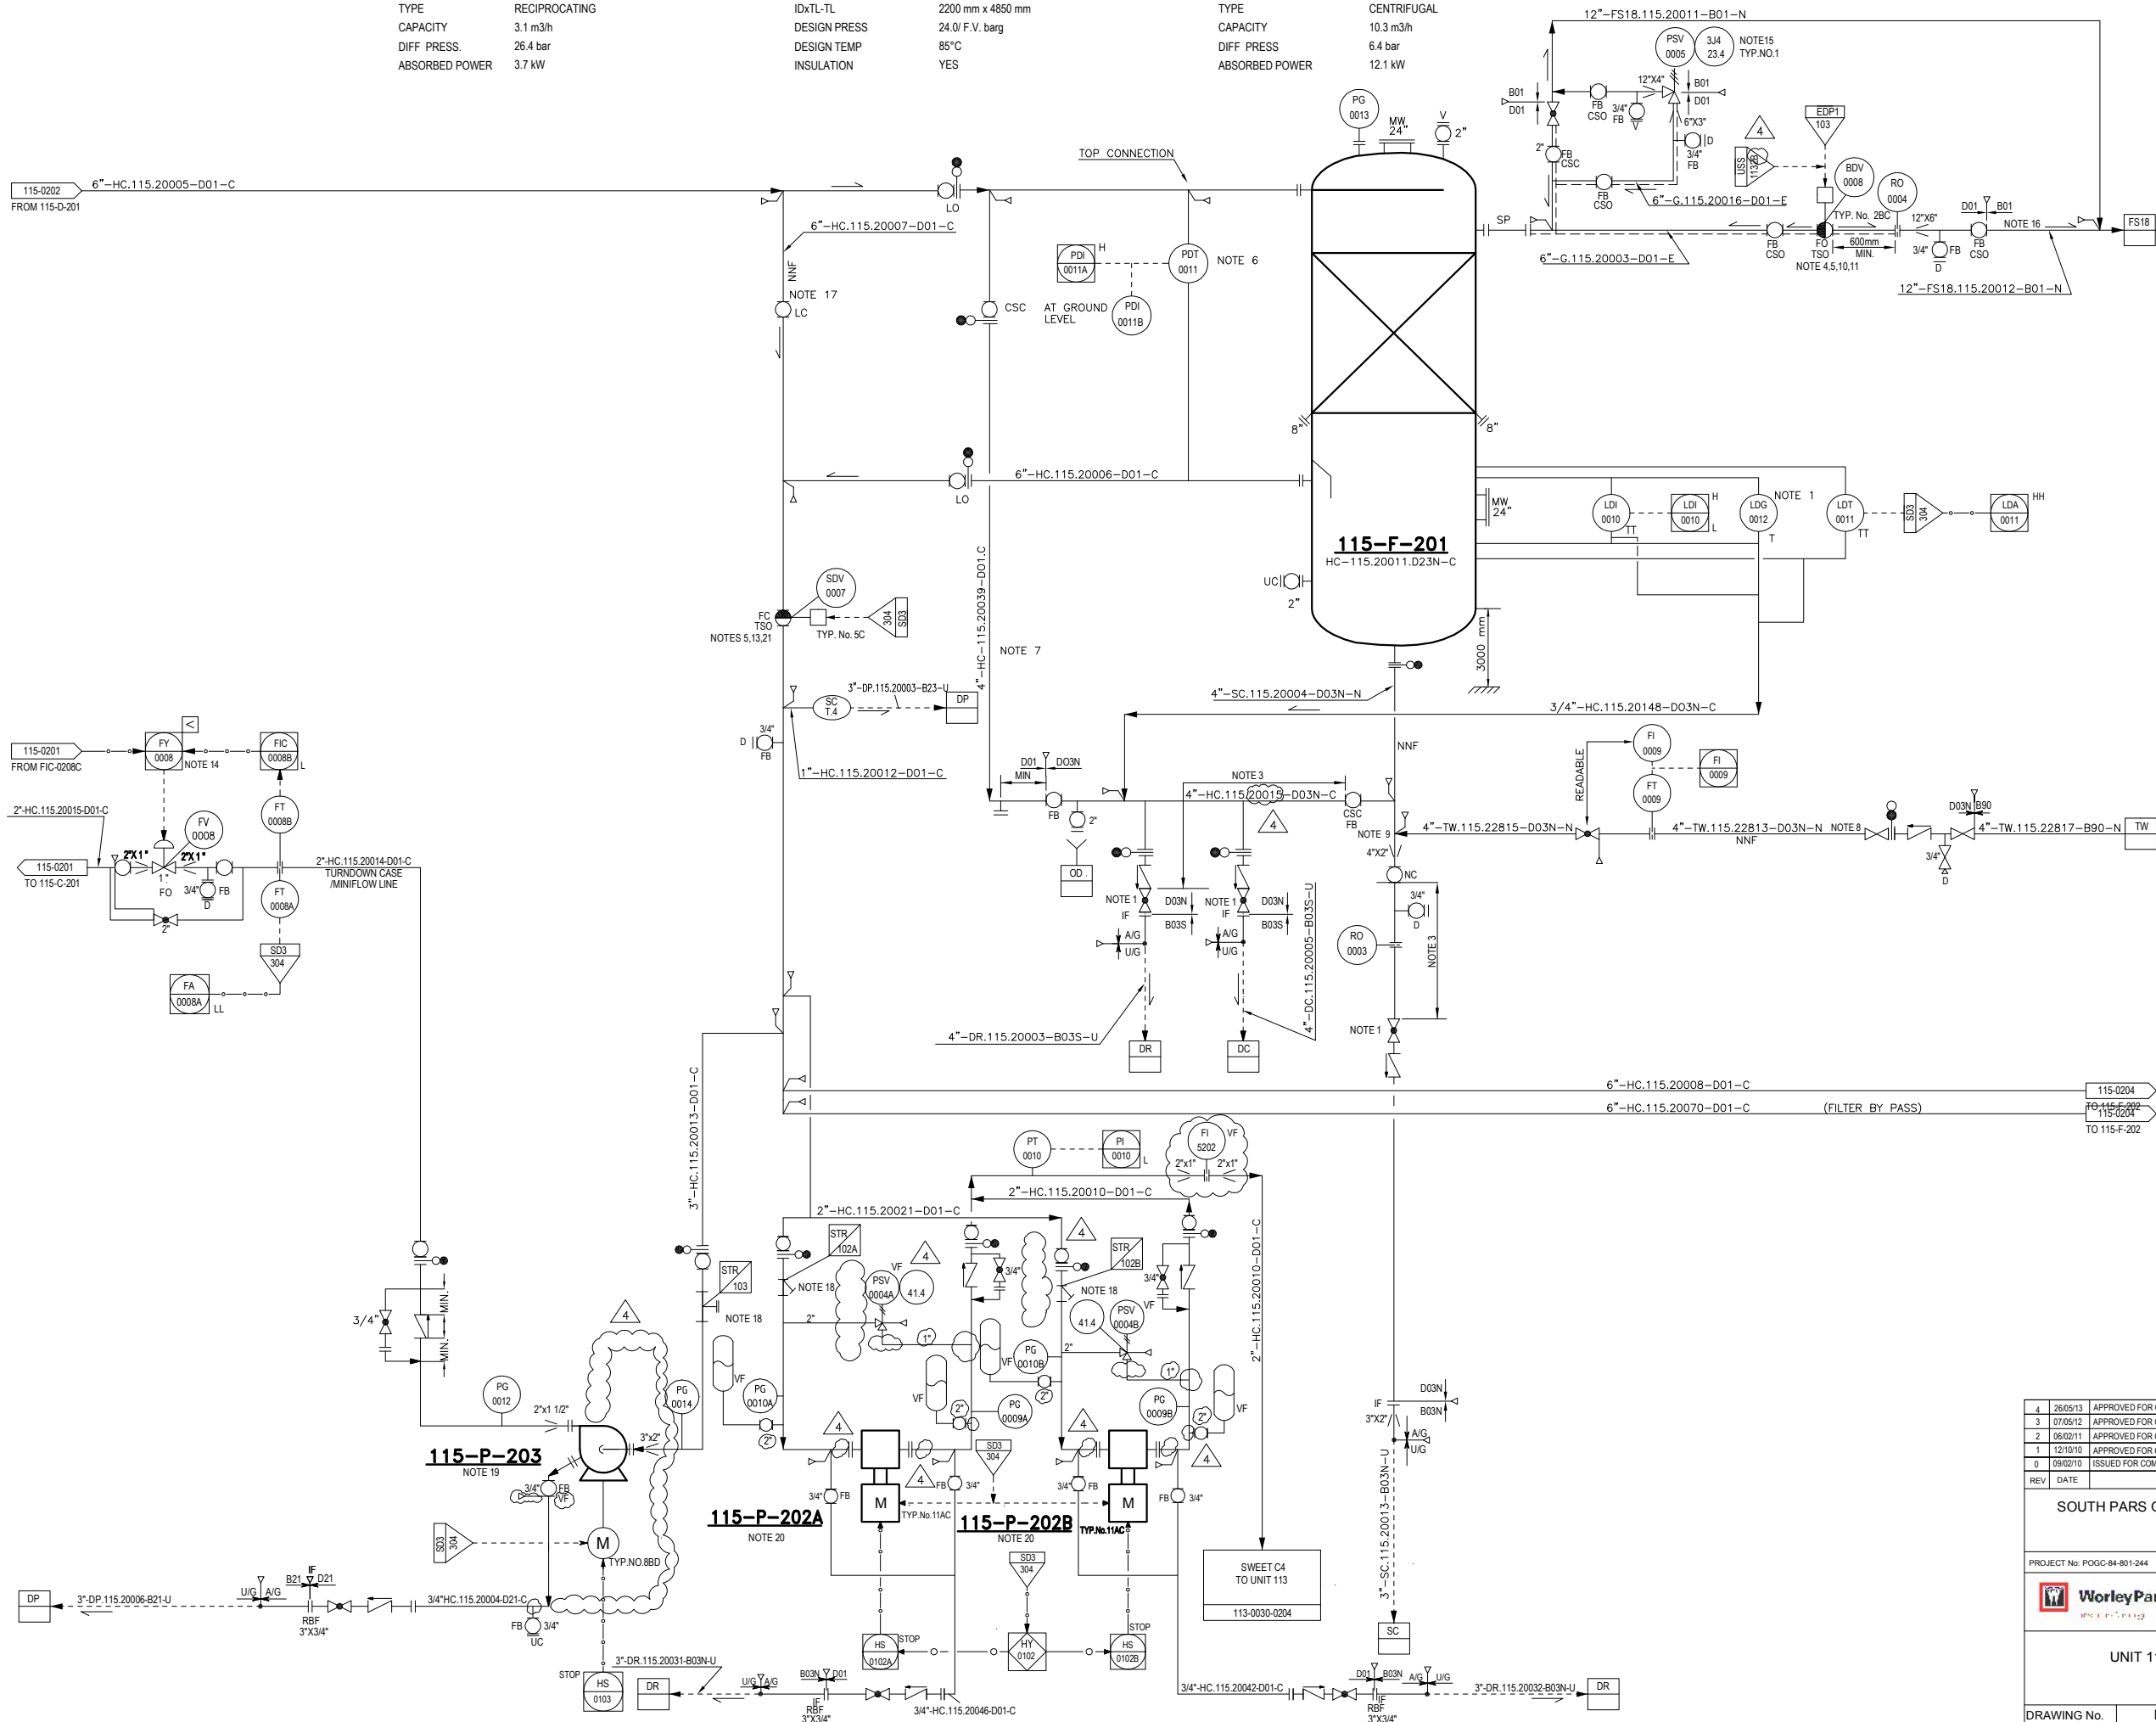

NOTES

 
- LDG ON 115-F-201 TO BE READABLE FROM GLOBE VALVES ON DRAIN LINES.
- SAND BED.
- PRESENCE OF C4. POSSIBILITY OF FREEZING VALVES IN CASE OF MISOPERATION. MINIMUM DISTANCE BETWEEN 2 VALVES SHALL BE 600 mm.
- VALVE EQUIPPED WITH AIR RESERVE.
- FIRE RESISTANT VALVE (ALL INSTRUMENTS, BOX PROTECTION, TUBING, CABLES, ETC., WILL BE SELECTED AND CLASSIFIED ACCORDING TO THIS PROTECTION).
- LOCATE DELTA P CELL AT LOW POINT. SELF DRAINING LEGS.
- FILTER BACK-WASH DRAIN PIPING.
- FOR SAND FILTER BACK-WASHING.
- CONNECTION ON TOP OF THE LINE.
- AIR RESERVE TO BE SIZED TO BE ABLE TO COMMAND FOR 3 STROKES VALVE OPERATING DURING AIR INSTRUMENT FAILURE.
- VALVE LOCATED AT HIGH POINT
- DELETED.
- ISOLATION VALVE TO BE LOCATED AT MINIMUM DISTANCE FROM 115-F-201.
- SEE SPECIAL LOOP DESCRIPTION IN SECTION 4 OF PROCESS DATA BOOK.
- SPARE RELIEF VALVE STORED IN WAREHOUSE.
- TWO PHASES FLOW LINE NEED FOR REINFORCED ANCHORING.
- SAND FILTER BY-PASS FOR MAINTENANCE.
- FOR FILTER ARRANGEMENT REFER TO TABLE "A" ON PID-1718-999-0030-0006.
- OPERATOR TO START THE PUMP WHEN IT IS NECESSARY.
- PSV, PULSTION DAMPENER AND ALL REQUIRED ACCESSORIES (AS PER PROJECT SPECIFICATION) SHALL BE SUPPLIED BY PUMP VENDOR.
- SDV-0007 CLOSED INDICATION TRIPS C4 TURN DOWN PUMP PUMP 115-P-202A/B AND 115-P-203 WHEN RUNNING.

GENERAL NOTES

ALL INSTRUMENT TAGS TO READ:
LETTERS NUMBER
1152 FFFF NNNN

HOLDS

- DELETED.
- DELETED.
- DELETED.



THIS P&ID IS BASED ON DRAWING NO. 115-SPD-3/6 SUPPLIED BY AXENS.

EQUIPMENT LIST

FILTER	PUMP		
115-F-201	115-P-202A/B		
	115-P-203		

UTILITY PID NUMBER

FS18	PID-1718-186-0040-0204	DC	PID-1718-186-0040-0205
DP	PID-1718-186-0040-0205	DR	PID-1718-186-0040-0205
TW	PID-1718-186-0040-0203	SC	PID-1718-186-0040-0205

4	26/05/13	APPROVED FOR CONSTRUCTION	OIEC	SD	SM	SM	RM
3	07/05/12	APPROVED FOR CONSTRUCTION	OIEC	SM	MM	SM	RM
2	06/02/11	APPROVED FOR CONSTRUCTION	OIEC	SM	MA	MMF	AAP
1	12/10/10	APPROVED FOR CONSTRUCTION	OIEC	SM	MA	MMF	AAP
0	09/02/10	ISSUED FOR COMMENT	OIEC	SM	MA	MMF	AAP
REV	DATE	DESCRIPTION	ORIGI	PRPD	CHD	APPD	AUTHD

SOUTH PARS GAS FIELD DEVELOPMENT P HASES 17&18
ASSALUYEH-IRAN
ONSHORE FACILITIES



PROJECT No: POGC-84-801-244

DOC. CLASS 1 SCALE: N/A



UNIT 115: BUTANE TREATMENT AND DRYING - PHASE 18
FILTRATION SECTION (TRAIN 2)
PIPING AND INSTRUMENT DIA/GRAM

DRAWING No.	PID-1718-115-0030-0203	REVISION	4
-------------	------------------------	----------	---

THIS DOCUMENT IS THE SOLE PROPERTY OF N.O.C. ALL INFORMATION CONTAINED HEREIN MAY NEITHER BE REPRODUCED, USED, DISCLOSED, TRANSMITTED OR IN ANY WAY MADE PUBLIC WITHOUT THE WRITTEN PERMISSION OF THE OWNER.

ITEM 115-F-202
SERVICE C4 SAND GUARD FILTER
DESIGN PRESS 24.0 bar g
DESIGN TEMP 85°C

ITEM 115-E-202
SERVICE C4 MOLECULAR SIEVES FEED/EFFLUENT EXCHANGER
TYPE AEU OR BEU
DUTY / SURFACE 0.426 MW / 20.1 m²
SHELL 12.9 bar g
DESIGN PRESS 200°C
INSULATION H

ITEM 115-H-201
SERVICE C4 MOLECULAR SIEVES REGENERATION ELECTRICAL HEATER
DUTY 504.2 kW
DESIGN PRESS 11.7 bar g
DESIGN TEMP 340°C

NOTES

- 1 - INSTRUMENTS AND CONTROL SYSTEM FOR EACH HEATER PASS WILL BE FINALIZED AFTER RECEIVING VENDOR DATA.
- 2 - RAMP OPERATION IS REQUIRED.
- 3 - VOTING SYSTEM. SD3 IS ACTIVATED BY AT LEAST TWO TSHH.
- 4 - TA-0021 LOW TEMPERATURE IS ALARM ONLY.
- 5 - FA-0021 HIGH FLOW IS ALARM ONLY.
- 6 - IF THE ADSORPTION PHASE END, BEFORE REGENERATION PHASE IS FINISHED, THESE QUENCH IS STOPPED AND UNIT 115 WILL BE SHUTDOWN.
- 7 - IN CASE OF HEATER TRIP, ALL VALVES IN REGENERATION CYCLE TO BE CLOSED.


HOLDS

- 1 - DELETED.
- 2 - CONTROL VALVE AND BYPASS VALVE SIZE.

GENERAL NOTES

ALL INSTRUMENT TAGS TO READ:
LETTERS NUMBER
1152 FFFF NNNN

DETAIL A (ON/OFF VALVE)

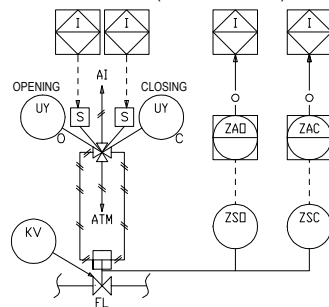

THIS P&ID IS BASED ON DRAWING NO. 115-5PD-4/6 SUPPLIED BY AXENS.

EQUIPMENT LIST

EXCHANGER	FILTER	HEATER
115-E-202	115-F-202	115-H-201

UTILITY PID NUMBER

FB18	PID-1718-186-0040-0204
DP	PID-1718-186-0040-0205

REV	DATE	DESCRIPTION	CRG	PRPD	CHD	APP'D	AUTH'D
4	26/05/13	APPROVED FOR CONSTRUCTION	OIEC	SD	SM	SM	RM
3	07/05/12	APPROVED FOR CONSTRUCTION	OIEC	SM	MMH	SM	RM
2	06/02/11	APPROVED FOR CONSTRUCTION	OIEC	SM	MA	MMF	AAP
1	12/10/10	APPROVED FOR CONSTRUCTION	OIEC	SM	MA	MMF	AAP
0	09/02/10	ISSUED FOR COMMENT	OIEC	SM	MA	MMF	AAP

SOUTH PARS GAS FIELD DEVELOPMENT PHASES 17&18
ASSALUYEH-IRAN
ONSHORE FACILITIES




PROJECT No: POGC-84-801-244


DOC. CLASS 1 SCALE: N/A




UNIT 115: BUTANE TREATMENT AND DRYING
BUTANE FILTRATION & REGENERATION ELECTRICAL HEATER (TRAIN 2)
PIPING AND INSTRUMENT DIAGRAM

DRAWING No. PID-1718-115-0030-0204 REVISION 4

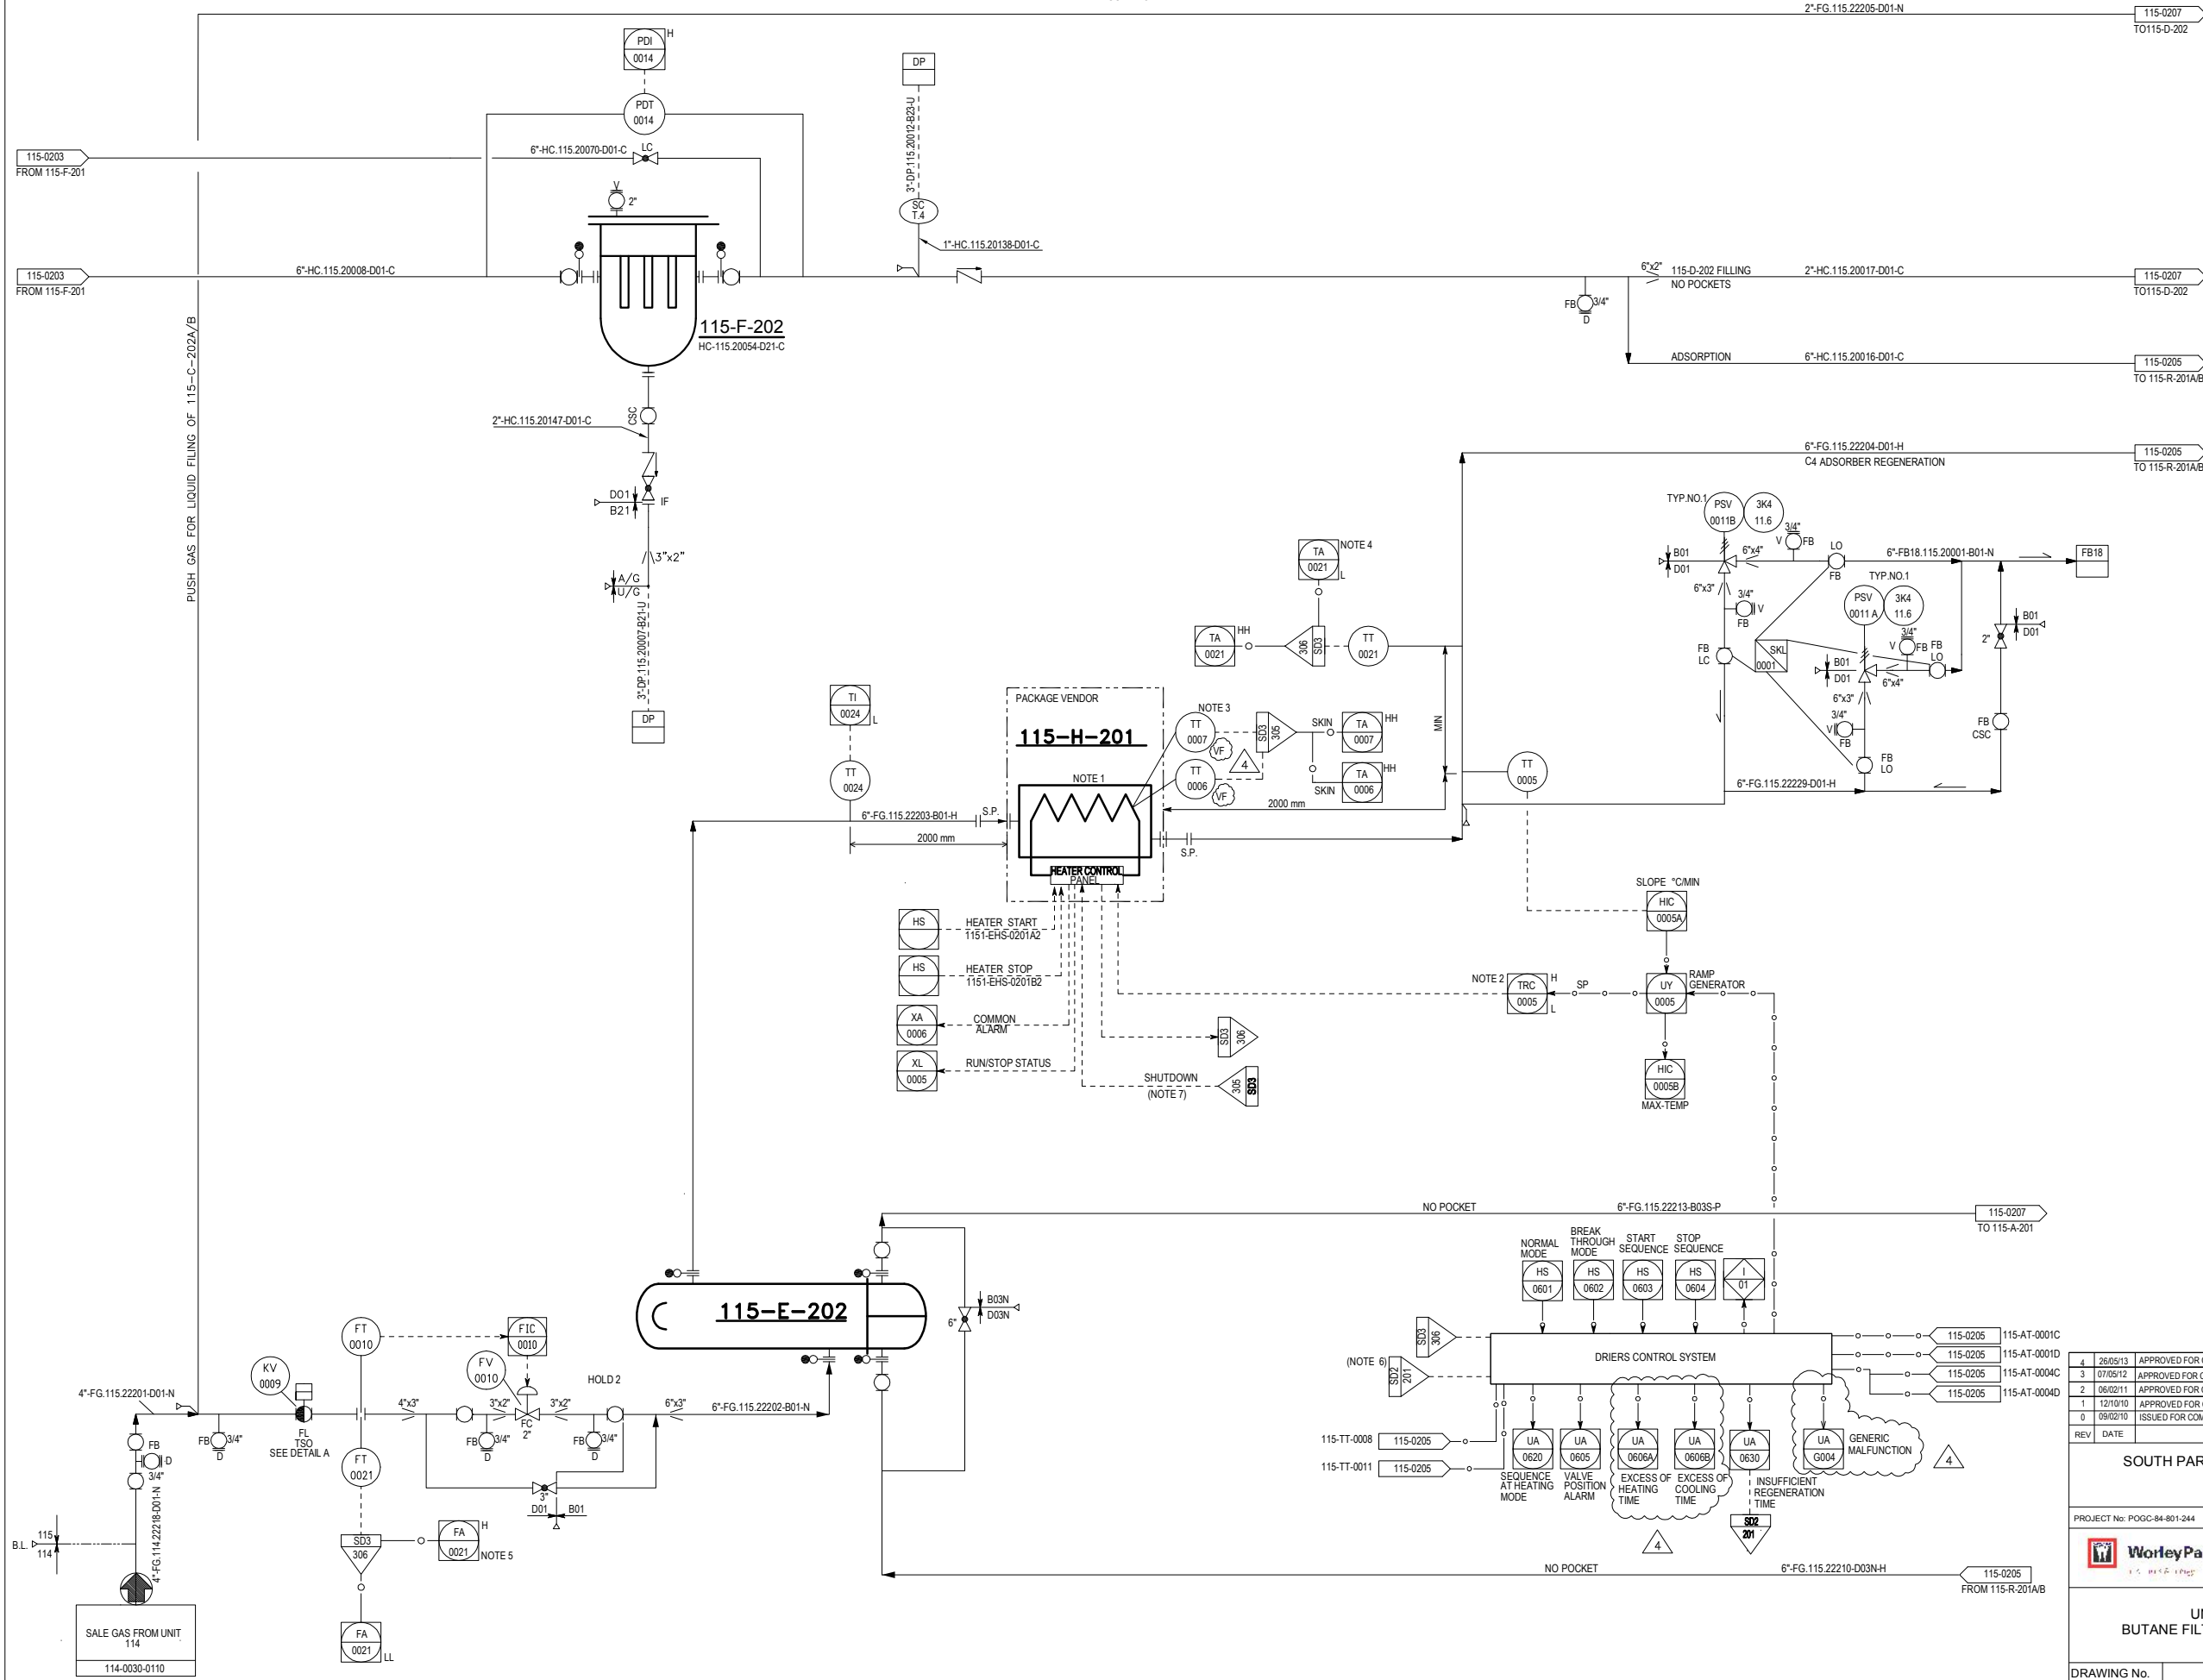

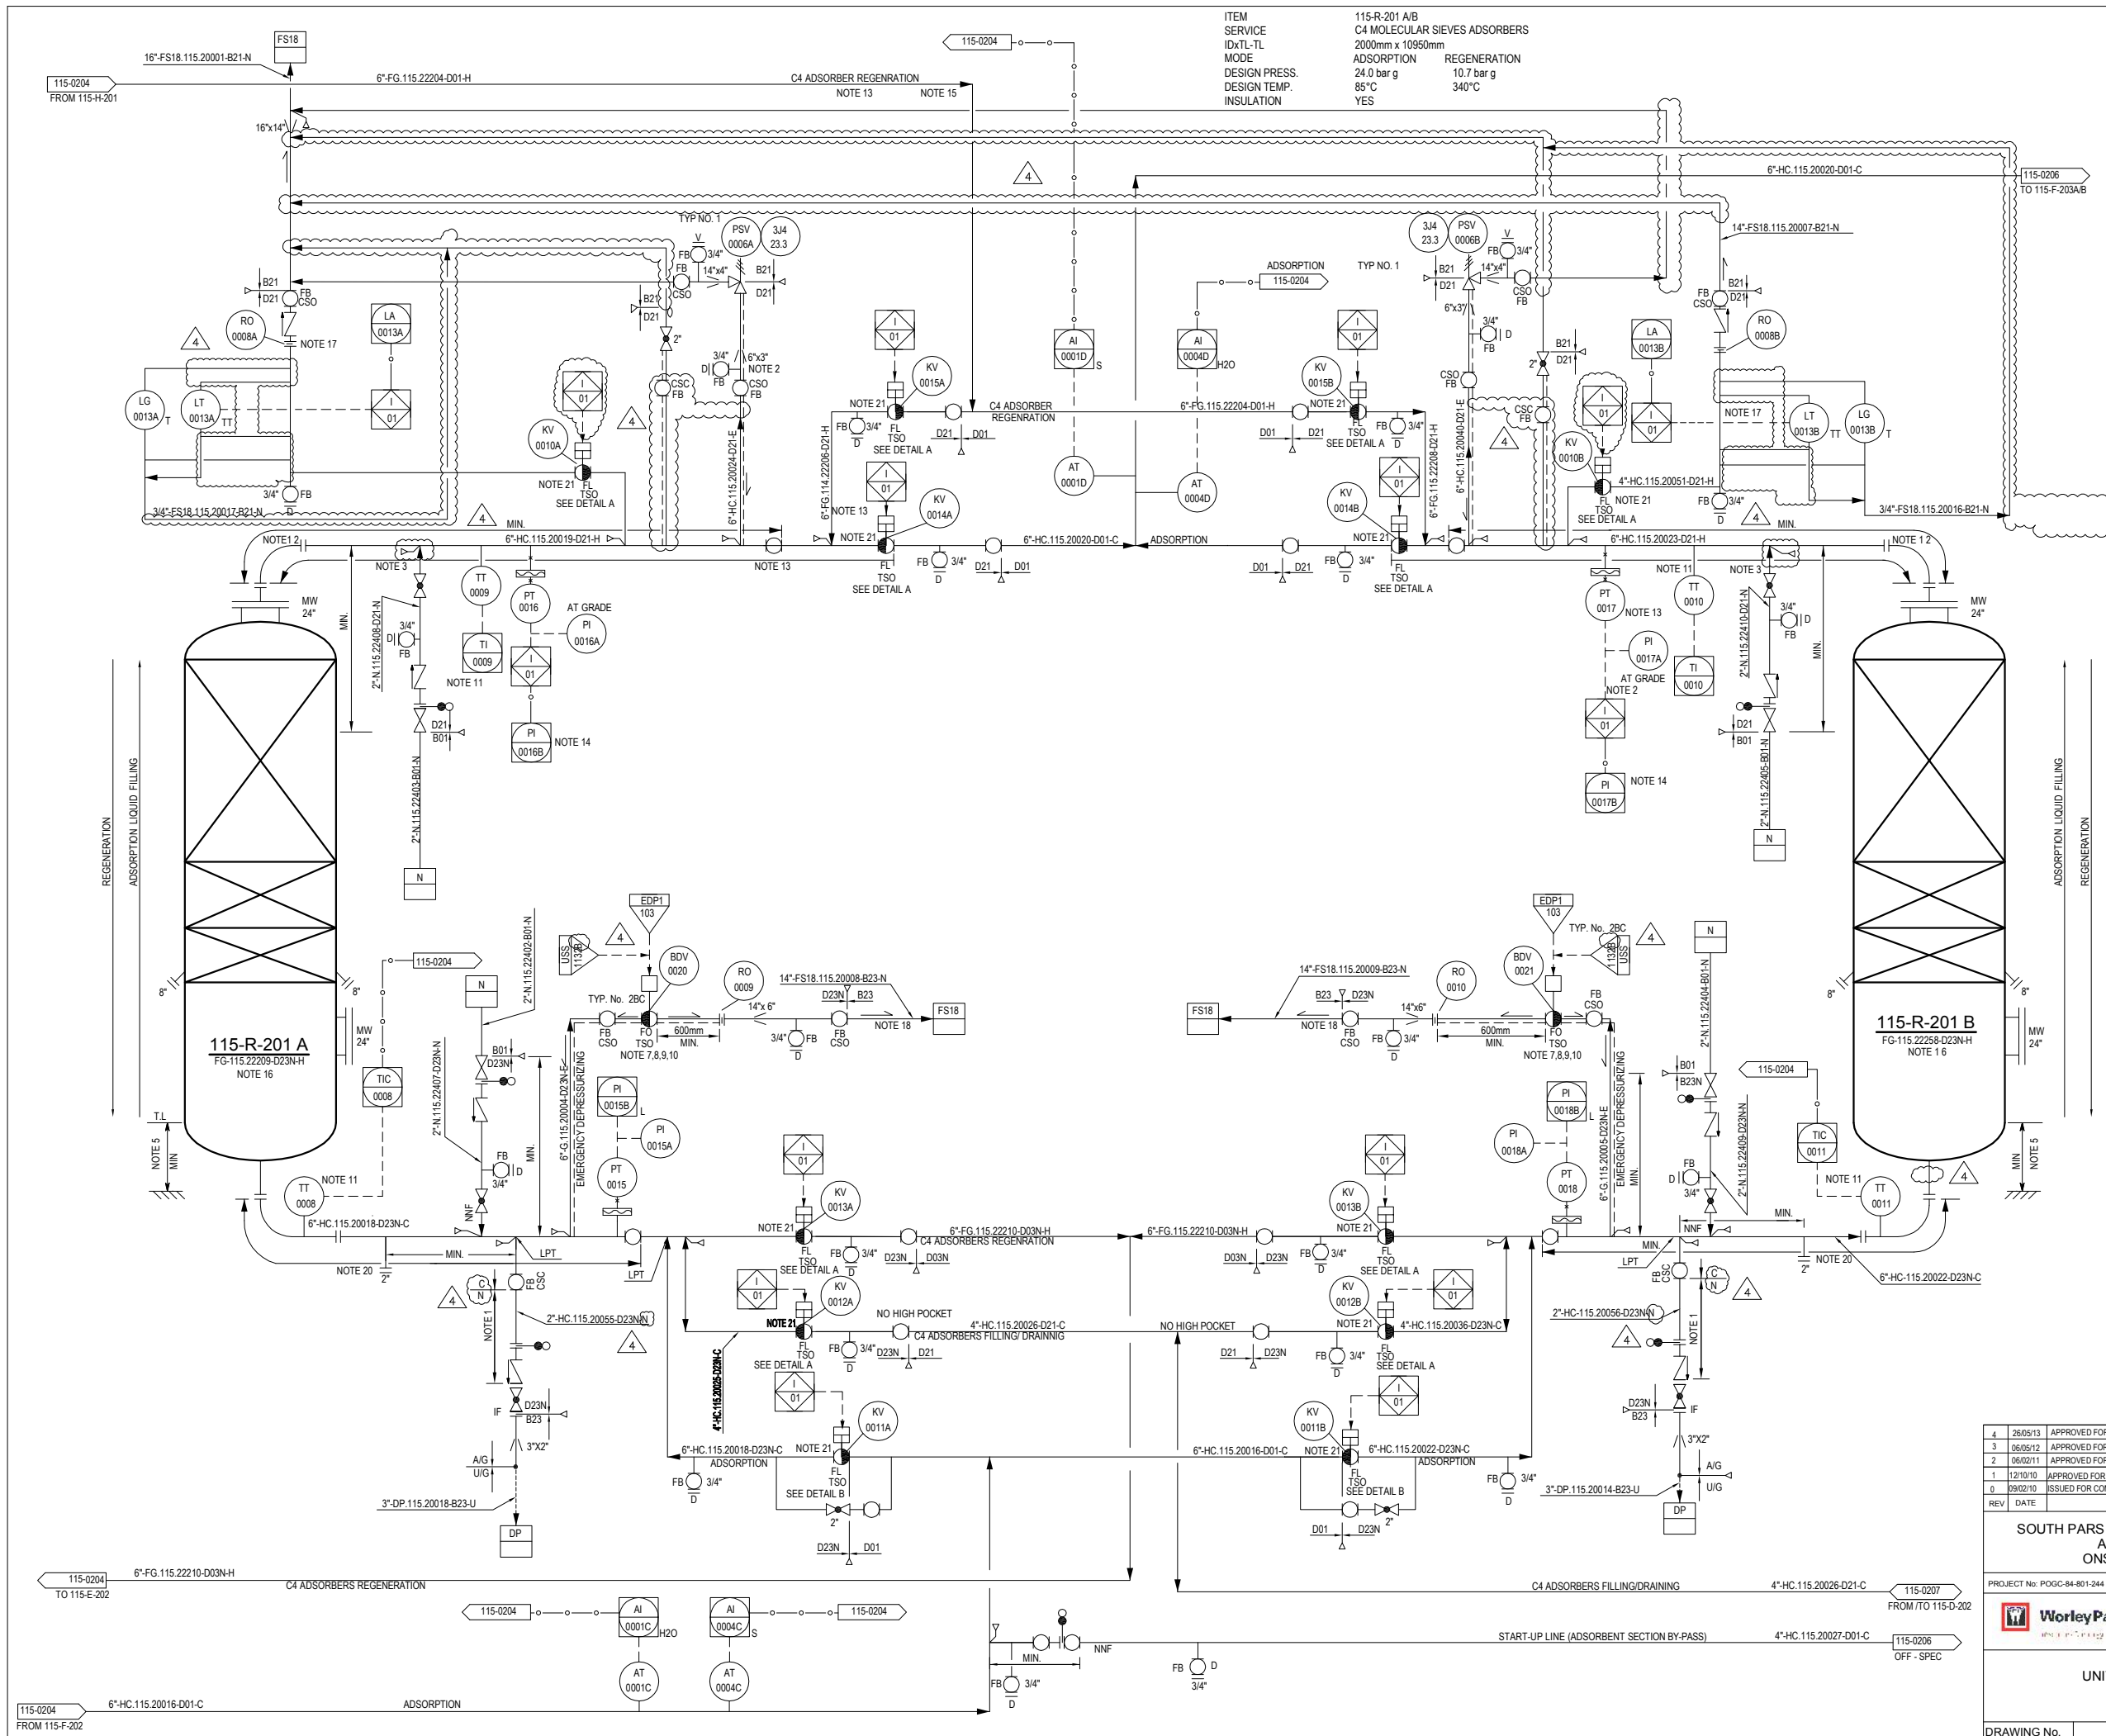

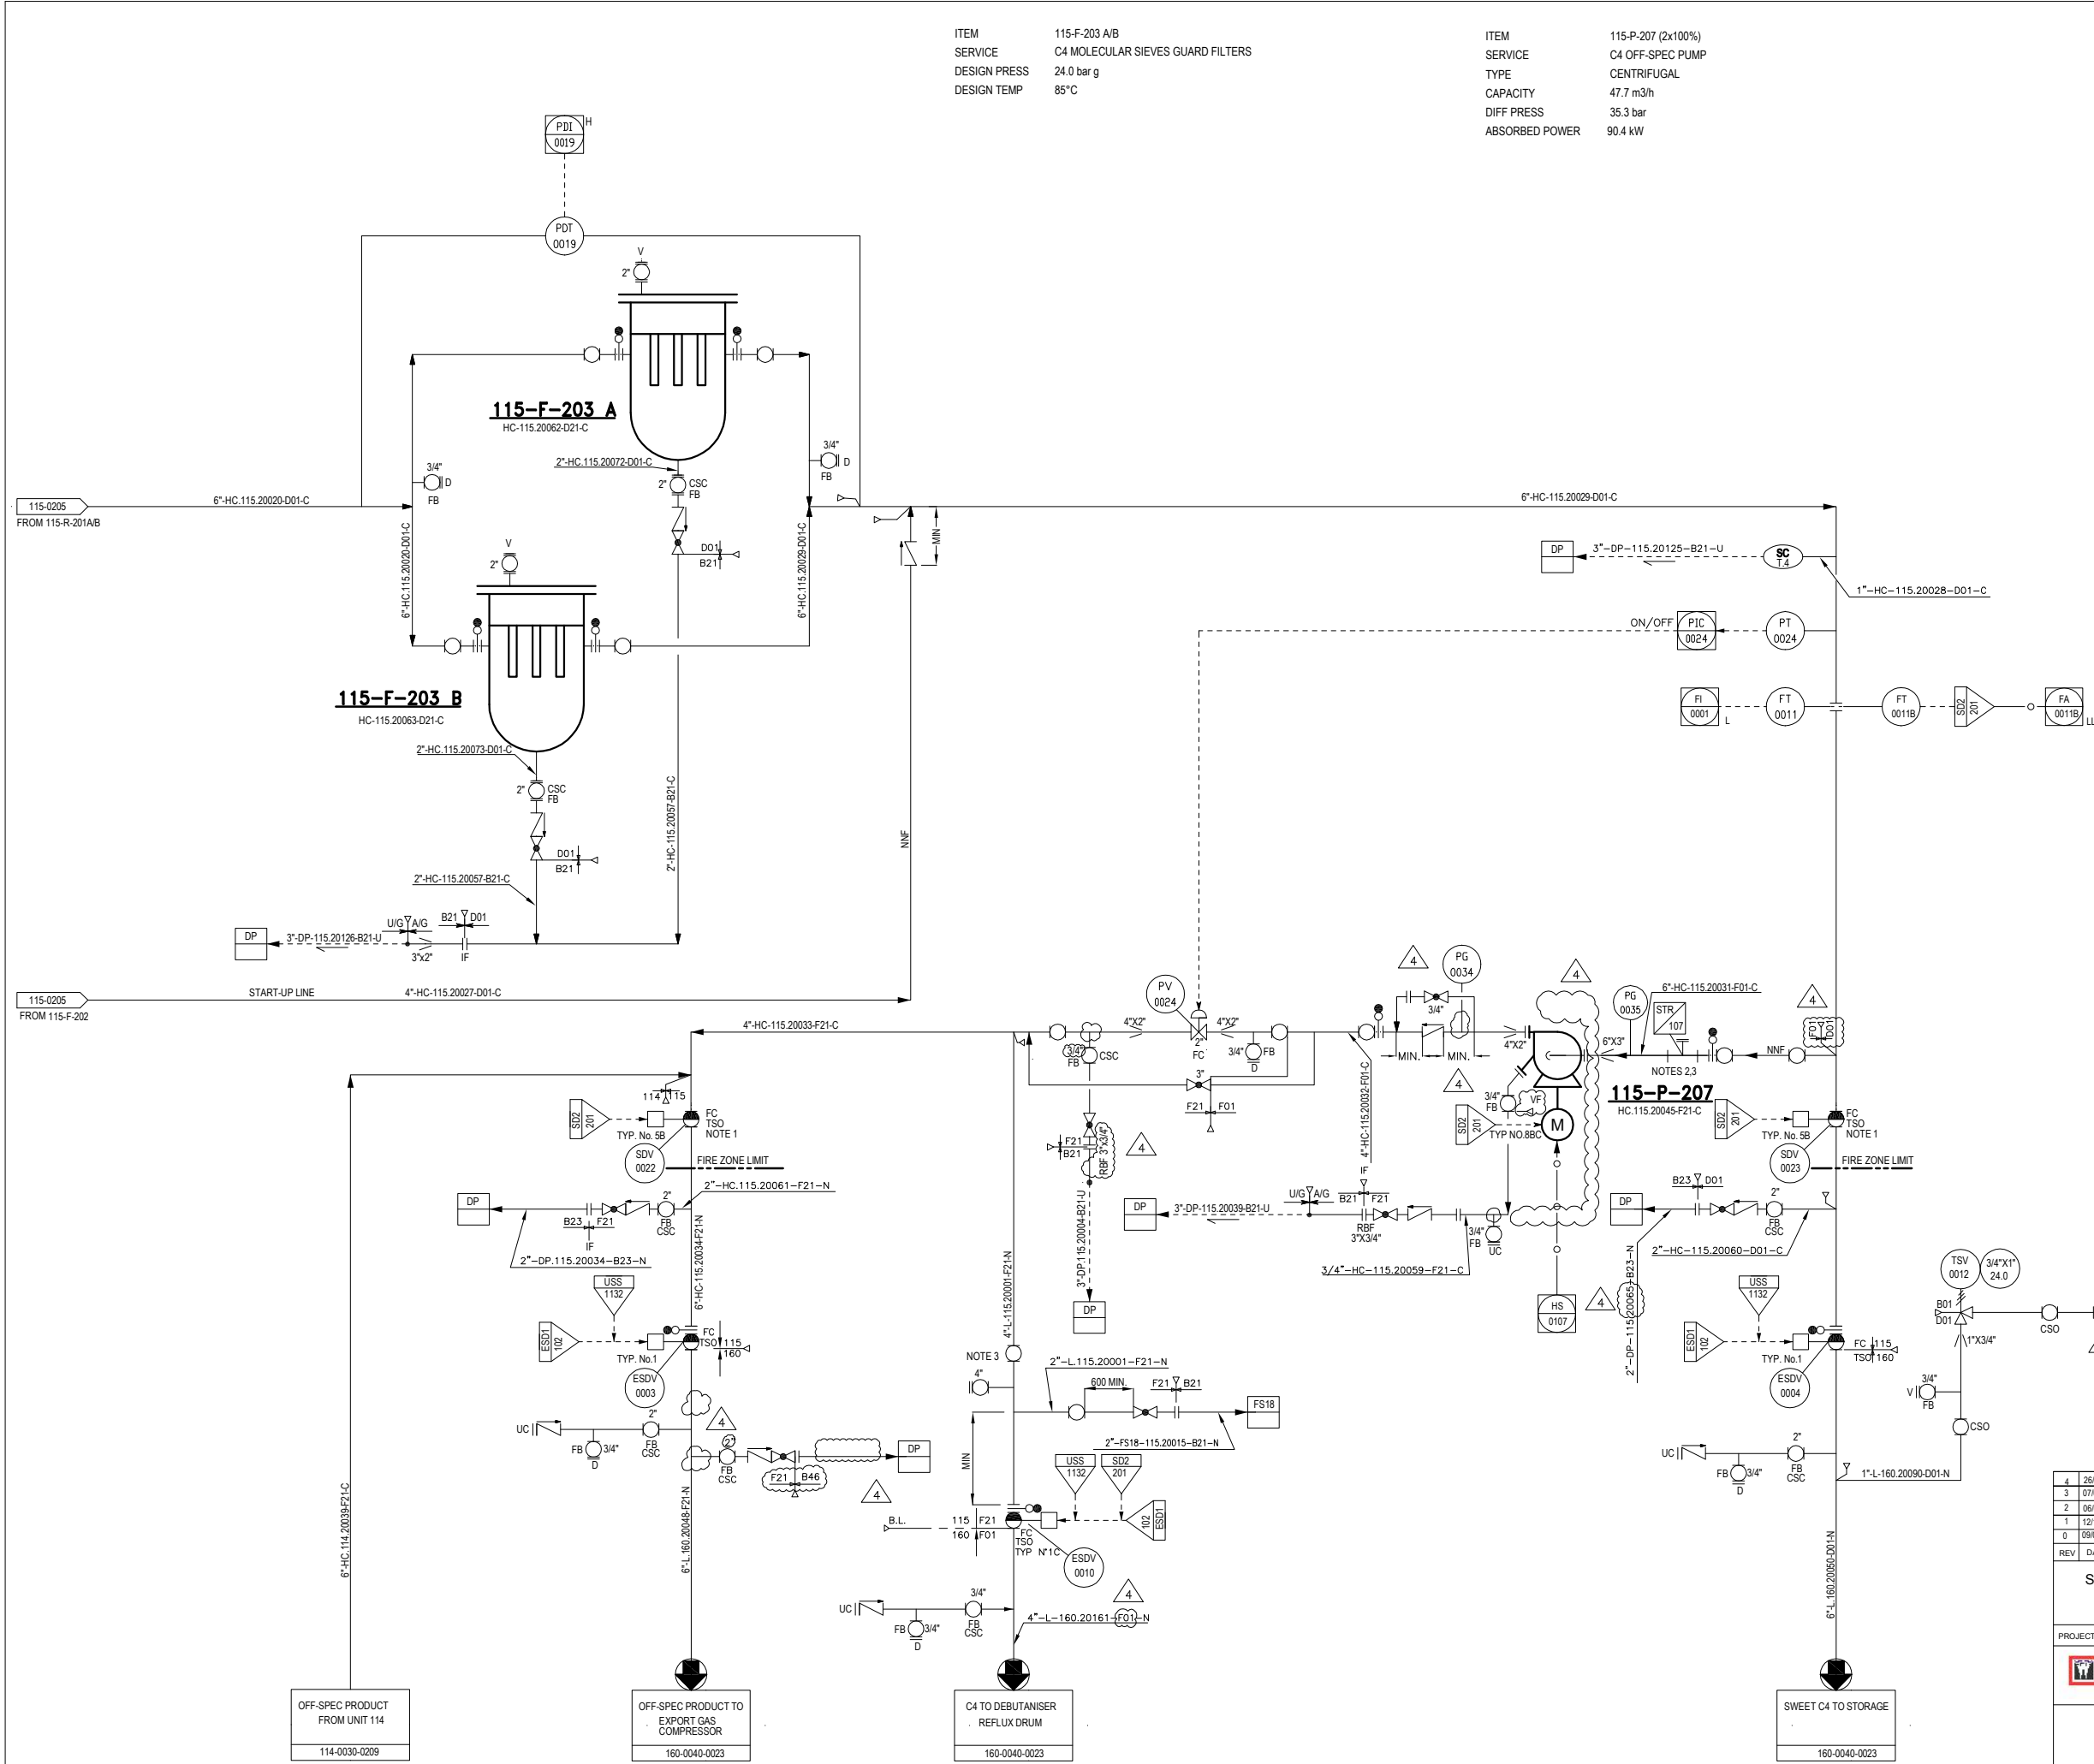

- NOTES**
- 1- FIRE RESISTANT VALVE (ALL INSTRUMENTS, BOX PROTECTION, TUBING, CABLES, ETC., WILL BE SELECTED AND CLASSIFIED ACCORDING TO THIS PROTECTION).
 - 2- FOR FILTER ARRANGMENT REFER TO TABLE "A" ON PID-1718-999-0030-0006.
 - 3- SUCTION AND DISCHARGE CONNECTIONS ARE FOR STATR-UP.

GENERAL NOTES

ALL INSTRUMENT TAGS TO READ:
LETTERS NUMBER
1152 FFFF NNNN

- HOLDS**
- 1- DELETED.
 - 2- DELETED.

THIS P&ID IS BASED ON DRAWING NO. 115-SPD-6/6 SUPPLIED BY AXENS.

EQUIPMENT LIST			
FILTER	PUMP		
115-F-203A/B	115-P-207		

UTILITY PID NUMBER	
DP	PID-1718-186-0040-0205
FS18	PID-1718-186-0040-0204

REV	DATE	DESCRIPTION	ORIGI	PRPD	CHD	APPD	AUTHD
4	26/05/13	APPROVED FOR CONSTRUCTION	OIEC	SD	SM	SM	RM
3	07/05/12	APPROVED FOR CONSTRUCTION	OIEC	SM	MMH	SM	RM
2	06/02/11	APPROVED FOR CONSTRUCTION	OIEC	SM	MA	MMF	AAP
1	12/10/10	APPROVED FOR CONSTRUCTION	OIEC	SM	MA	MMF	AAP
0	09/02/10	ISSUED FOR COMMENT	OIEC	SM	MA	MMF	AAP

SOUTH PARS GAS FIELD DEVELOPMENT PHASES 17&18 ASSALUYEH-IRAN ONSHORE FACILITIES				POGC
PROJECT No: POGC-84-801-244		DOC. CLASS	1	SCALE: N/A
UNIT 115: BUTANE TREATMENT AND DRYING C4 PRODUCT EXPORT SECTION PIPING AND INSTRUMENT DIA/GRAM				
DRAWING No.	PID-1718-115-0030-0206			REVISION 4

THIS DOCUMENT IS THE SOLE PROPERTY OF N.L.O.C. ALL INFORMATION CONTAINED HEREIN MAY NEITHER BE REPRODUCED, USED, DISCLOSED, TRANSMITTED OR IN ANY WAY MADE PUBLIC WITHOUT THE WRITTEN PERMISSION OF THE OWNER.

ITEM	115-D-202	ITEM	115-A-201
SERVICE	ADSORBERS DRAINING/FILLING DRUM	SERVICE	REGENERATION GAS CONDENSER
IDxTL-TL	2300mm x 6850mm	DUTY/SURFACE	0.334 MW/23 m2
DESIGN PRESS	12.6/F.V. barg	DESIGN PRESS	10.7 barg
DESIGN TEMP	85°C	DESIGN TEMP	200°C
INSULATION	YES	INSTALLED POWER	11 KW

ITEM	115-E-201	ITEM	115-D-203
SERVICE	REGENERATION GAS TRIM COOLER	SERVICE	REGENERATION K.O. DRUM
TYPE	DOUBLE PIPE	IDxTL-TL	750mm x 2300mm
DUTY/SURFACE	0.066/68 m2	DESIGN PRESS	9.1/F.V. barg
	SHELL	DESIGN TEMP	185°C
DESIGN PRESS	11.5 barg	INSULATION	NO
DESIGN TEMP	185°C		
INSULATION	N		

ITEM	115-D-203
SERVICE	REGENERATION K.O. DRUM
IDxTL-TL	750mm x 2300mm
DESIGN PRESS	9.1/F.V. barg
DESIGN TEMP	185°C
INSULATION	NO

NOTES

- 1- PRESENCE OF LPG, POSSIBILITY OF FREEZING VALVES IN CASE OF MISOPERATION MINIMUM DISTANCE BETWEEN TWO VALVES SHALL BE 600 mm.
- 2- VALVE EQUIPPED WITH AIR RESERVE.
- 3- FIRE RESISTANT VALVE (ALL INSTRUMENTS, BOX PROTECTION, TUBING, CABLES,...ETC, WILL BE SELECTED AND CLASSIFIED ACCORDING TO THIS PROTECTION).
- 4- VALVE LOCATED AT HIGH POINT.
- 5- AIR RESERVE TO BE SIZED TO BE ABLE TO COMMAND FOR 3 STROKES VALVE OPERATING DURING AIR INSTRUMENT FAILURE.
- 6- FOR SAFETY REASON.
- 7- TWO PHASES FLOW LINE, NEED FOR REINFORCED ANCHORING.
- 8- PIC HAS TWO SET POINTS: ONE FOR DRAINING PHASE AND ONE FOR FILLING PHASE.
- 9- RISING STEM BALL VALVE.
- 10- NUMBER OF AIR COOLER BAYS IS 1.

GENERAL NOTES


ALL INSTRUMENT TAGS TO READ:
LETTERS NUMBER

1152 FFF NNNN

HOLDS


- 1- DELETED.
- 2- DELETED.
- 3- DELETED.

DETAIL A (ON/OFF VALVE)

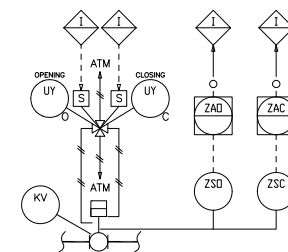

DETAIL B (RAMP OPENING VALVE)

A RAMP SHALL BE INSTALLED ON THE AIR CIRCUIT FOR OPENING POSITION. (CLOSED TO OPEN POSITION IN 2 MINUTES APPROXIMATELY)

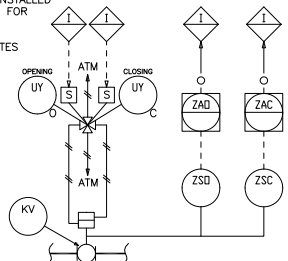

THIS P&ID IS BASED ON DRAWING NO. 115-5PD-7/8 SUPPLIED BY AXENS.

DRUM	EXCHANGER	AIR COOLER
115-D-202	115-E-201	115-A-201
115-D-203		

UTILITY PID NUMBER

FB18	PID-1718-186-0040-0204	FS18	PID-1718-186-0040-0204
SW	PID-1718-186-0040-0203	DS	PID-1718-186-0040-0205
DR	PID-1718-186-0040-0205		

REV	DATE	DESCRIPTION	ORIGI	PRPD	CHD	APPD	AUTHD
4	26/05/13	APPROVED FOR CONSTRUCTION	OIEC	SD	SM	SM	RM
3	07/05/12	APPROVED FOR CONSTRUCTION	OIEC	SM	MMH	SM	RM
2	06/02/11	APPROVED FOR CONSTRUCTION	OIEC	SM	MA	MMF	AAP
1	12/10/10	APPROVED FOR CONSTRUCTION	OIEC	SM	MA	MMF	AAP
0	09/02/10	ISSUED FOR COMMENT	OIEC	SM	MA	MMF	AAP

SOUTH PARS GAS FIELD DEVELOPMENT PHASES 17&18 ASSALUYEH-IRAN ONSHORE FACILITIES




PROJECT No: POGC-84-801-244 DOC. CLASS 1 SCALE: N/A

--	--	--	--

UNIT 115: BUTANE TREATMENT AND DRYING REGENERATION COOLING SECTION (TRAIN 2) PIPING AND INSTRUMENT DIAGRAM

DRAWING No.	PID-1718-115-0030-0207	REVISION	4
-------------	------------------------	----------	---

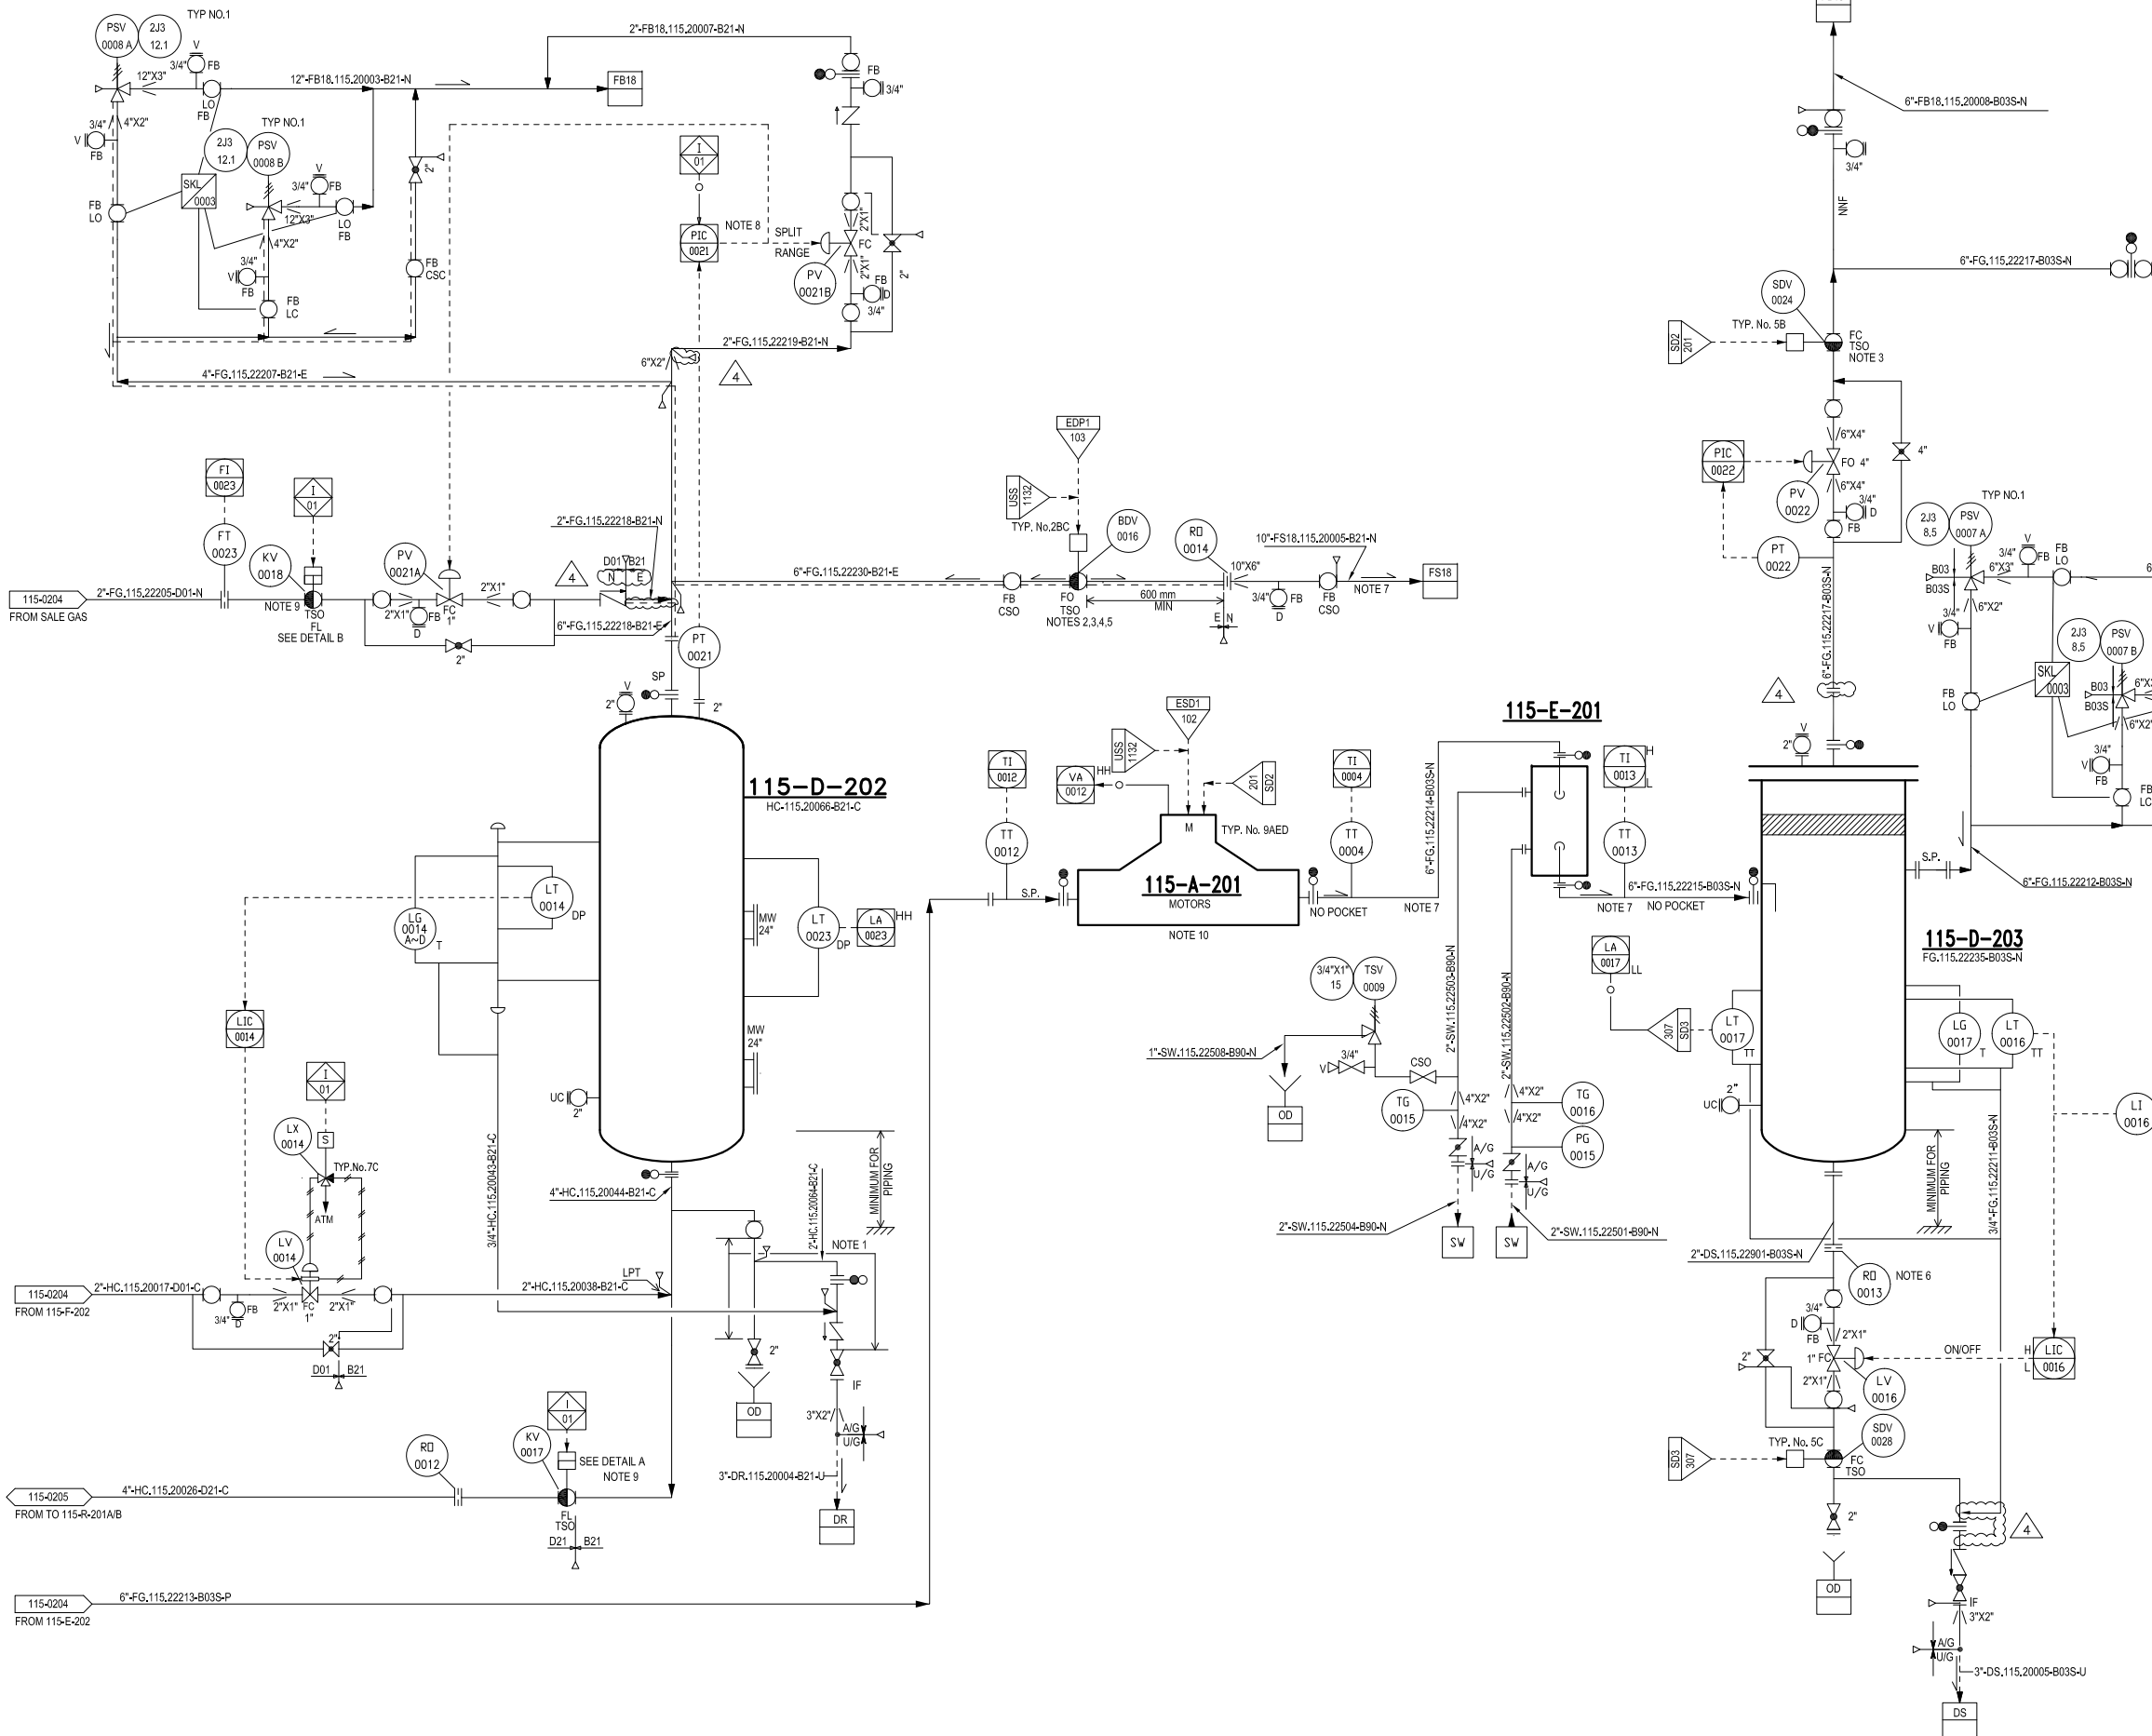

THIS DOCUMENT IS THE SOLE PROPERTY OF N.L.O.C. ALL INFORMATION CONTAINED HEREIN MAY NOT BE REPRODUCED OR TRANSMITTED IN ANY FORM OR BY ANY MEANS, ELECTRONIC OR MECHANICAL, INCLUDING PHOTOCOPYING, RECORDING, OR BY ANY INFORMATION STORAGE AND RETRIEVAL SYSTEM, WITHOUT THE WRITTEN PERMISSION OF THE OWNER.

ITEM
SERVICE
TYPE
CAPACITY
DIFF. PRESS.
ABSORBED POWER

115-P-206 A/B (2x100%)
WATER CIRCULATION PUMPS
CENTRIFUGAL
91 m³/h
2.1 bar
1.7kw

ITEM
SERVICE
TYPE
DUTY/SURFACE
DESIGN. PRESS.
DESIGN. TEMP.
INSULATION


115-E-203
CAUSTIC RECYCLE HEATER
DOUBLE PIPE
0.347 MW/6.2 m²
SHELL TUBE
14.3barg 11.0 barg
85°C 270°C
H H

ITEM
SERVICE
IDXTLTL
DESIGN. PRESS.
DESIGN. TEMP.
INSULATION

115-C-202
C4 CAUSTIC SCRUBBER
TOP:800mmx12000mm
BOTTOM:2400mmx3800mm
8.5 barg TOP/9.4 barg BOT/FV
85°C
YES

ITEM
SERVICE
TYPE
CAPACITY
DIFF. PRESS.
ABSORBED POWER

115-P-205 A/B (2x100%)
CAUSTIC CIRCULATION PUMPS
CENTRIFUGAL
13.6m³/h
3.5 bar
4.7kW

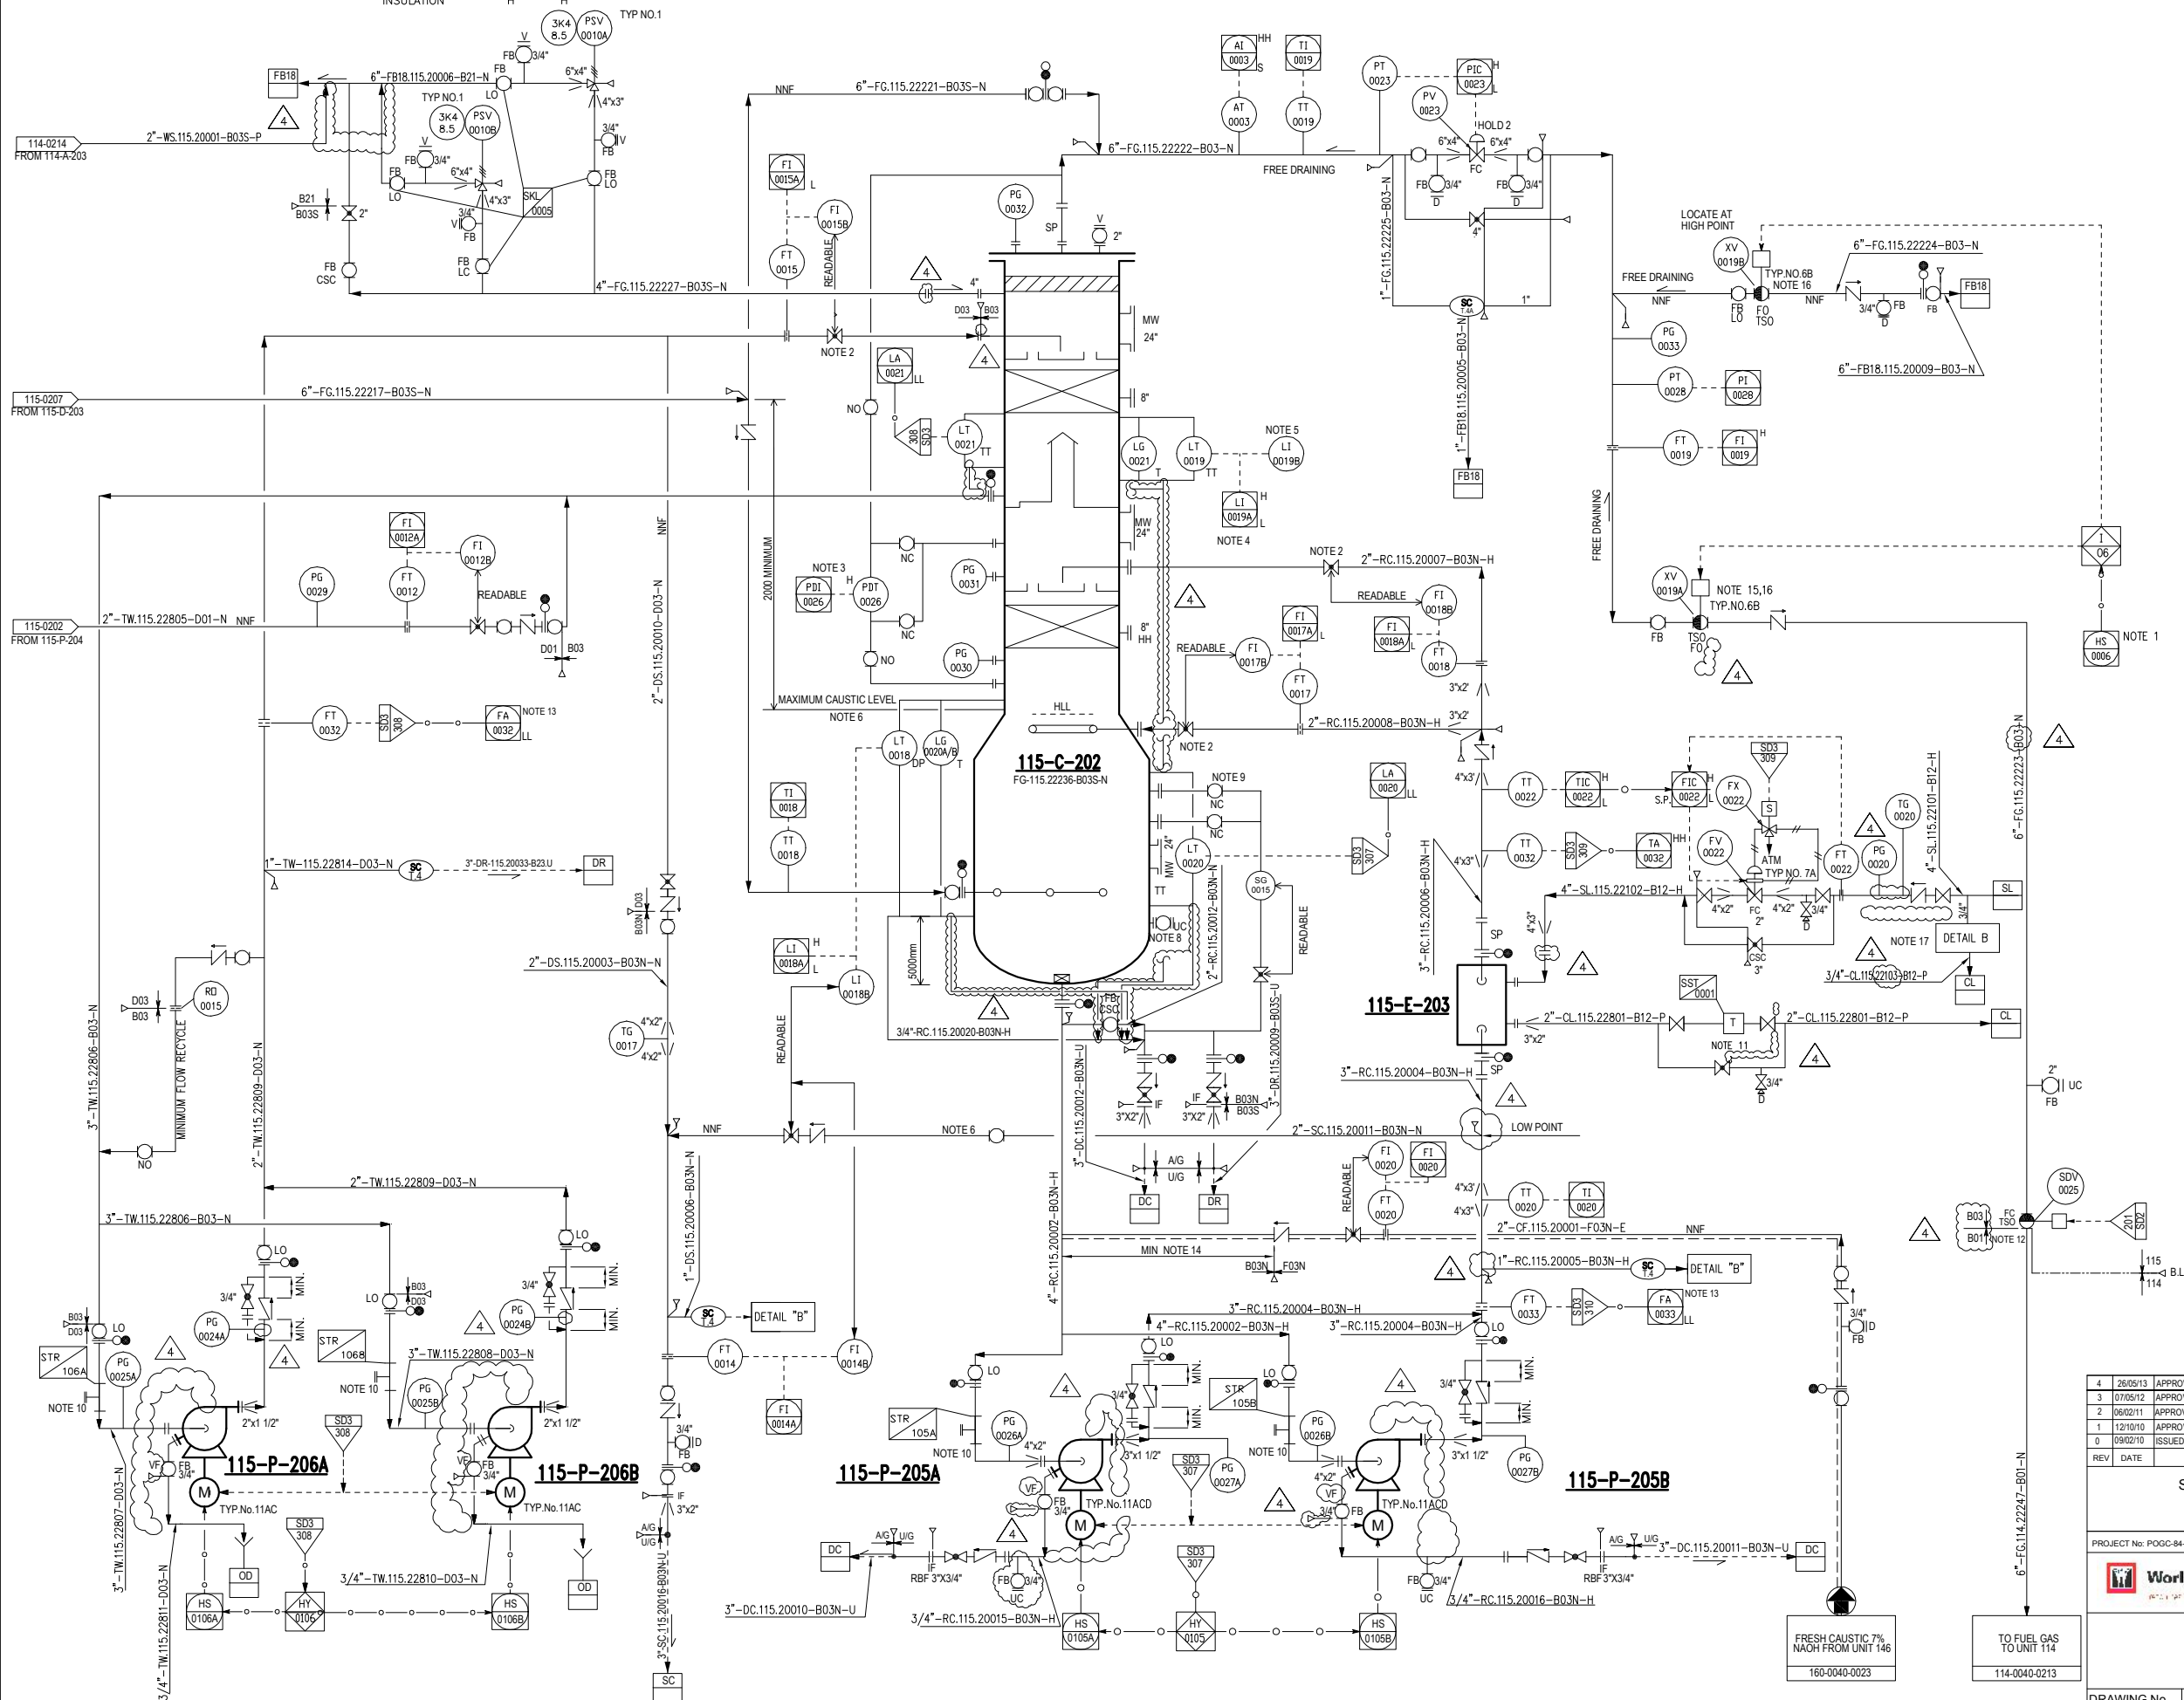

NOTES

- 1- OPERATOR SHOULD BE ABLE TO SWITCH FROM FUEL GAS TO FLARE DURING NORMAL OPERATION IN CASE OF SCRUBBER UPSET.
- 2- VALVE WITH MECHANICAL LIMIT STOP (IN ORDER TO AVOID FULL CLOSURE OF VALVE)
- 3- INSTRUMENT SHALL BE SELF-DRAINING.
- 4- HLL MUST BE DEFINED AT CHIMNEY TOP. TOWER WILL BE OPERATED UNDER AT HLL/HIGH LIQUID LEVEL.
- 5- LI TO BE READABLE FROM GLOBE VALVE ON DEMINERALIZED WATER.
- 6- FOR CAUSTIC INVENTORY REMOVAL OPERATION.
- 7- DELETED.
- 8- NO STEAM-OUT IS ALLOWED IF CAUSTIC SODA IS NOT PROPERLY REMOVED FROM SCRUBBER.
- 9- FOR HC PHASE DRAINING SKIMMING.
- 10- FOR FILTER ARRANGEMENT REFER TO TABLE "A" ON PID-1718-999-0030-0006.
- 11- STEAM TRAP.
- 12- FIRE RESISTANT VALVE (ALL INSTRUMENTS, BOX PROTECTION, TUBING, CABLES, ETC., WILL BE SELECTED AND CLASSIFIED ACCORDING TO THIS PROTECTION).
- 13- ON LOW FLOW FLOW DUTY PUMP IS STOPPED AND STANDBY PUMP STARTED IF AFTER 30 SECONDS FLOW REMAINS LOW, PUMPS ARE TRIPPED.
- 14- DISTANCE TO BE MINIMIZED.
- 15- A RAMP SHALL BE INSTALLED ON THE AIR CIRCUIT FOR OPENING AND CLOSING POSITIONS (CLOSE TO OPEN IN 2 MINUTES APPROXIMATELY. OPENING AND CLOSING TIME BE TUNABLE IN ORDER TO BE ADJUSTED ON SITE.)
- 16- RISING STEM BALL VALVE.
- 17- DRIP LEG. FOR DETAIL "A" REFER TO PID-1718-186-0040-0001.


HOLDS

- 1- DELETED.
- 2- DELETED.
- 3- DELETED.

GENERAL NOTES

ALL INSTRUMENT TAGS TO READ:
LETTERS NUMBER
1152 FFF NNNN

DETAIL "B"

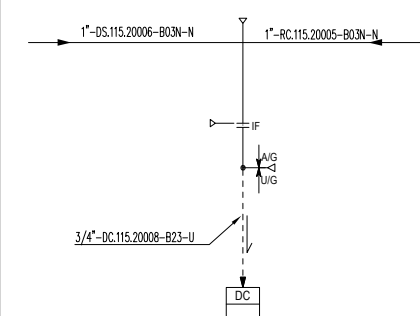

EQUIPMENT LIST

COLUMN	PUMPS	EXCHANGER
115-C-202	115-P-205A/B 115-P-206A/B	115-E-203

UTILITY PID NUMBER

DC	PID-1718-186-0040-0205	SL	PID-1718-186-0040-0201
DR	PID-1718-186-0040-0205	CL	PID-1718-186-0040-0201
FB18	PID-1718-186-0040-0204		
SC	PID-1718-186-0040-0205		

REV	DATE	DESCRIPTION	ORIGI	PRPDR	CHD	APPR	AUTHD
4	26/05/13	APPROVED FOR CONSTRUCTION					
3	07/05/12	APPROVED FOR CONSTRUCTION					
2	06/02/11	APPROVED FOR CONSTRUCTION					
1	12/10/10	APPROVED FOR CONSTRUCTION					
0	09/02/10	ISSUED FOR COMMENT					

**SOUTH PARS GAS FIELD DEVELOPMENT
PHASES 17&18 ASSALUYEH-IRAN
ONSHORE FACILITIES**

PROJECT NO: POGC-84-801-244

DOC. CLASS 1 SCALE: N/A

WorleyParsons **IDRO** **OIEC** **IOEC**

**UNIT 115: BUTANE TREATMENT AND DRYING
CAUSTIC SCRUBBER (TRAIN 2)
PIPING AND INSTRUMENT DIAGRAM**

DRAWING No. PID-1718-115-0030-0208

REVISION 4